




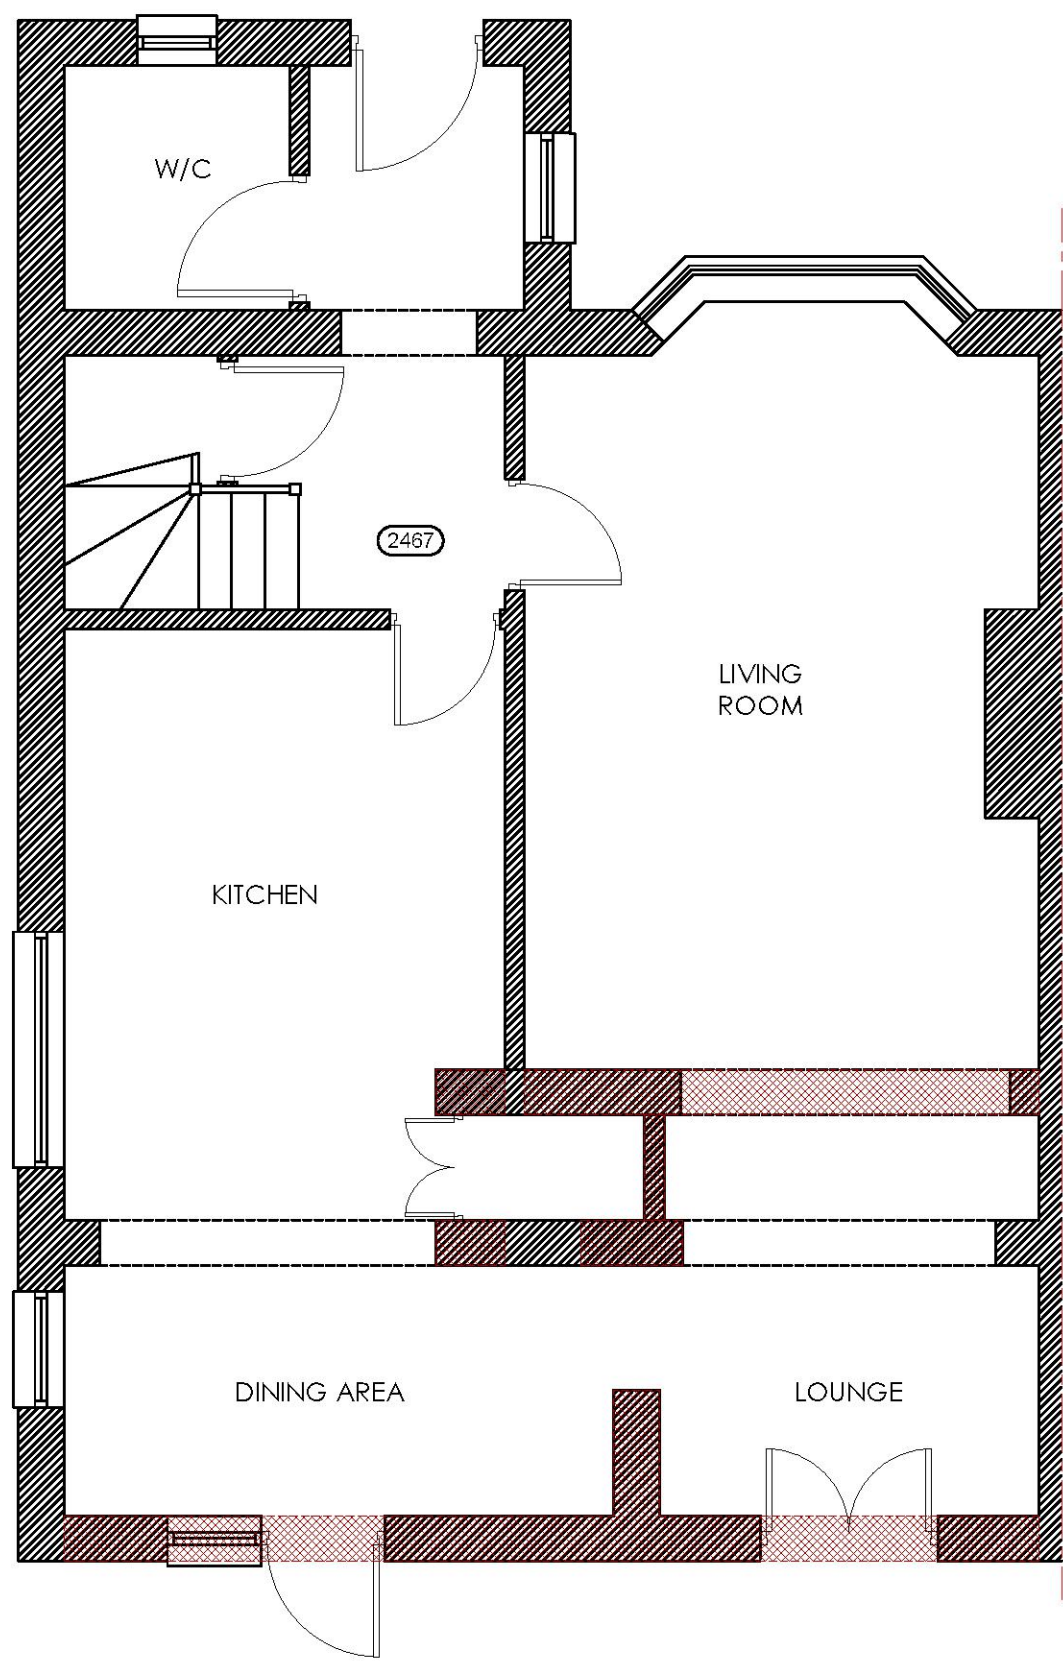

EXISTING GROUND FLOOR PLAN

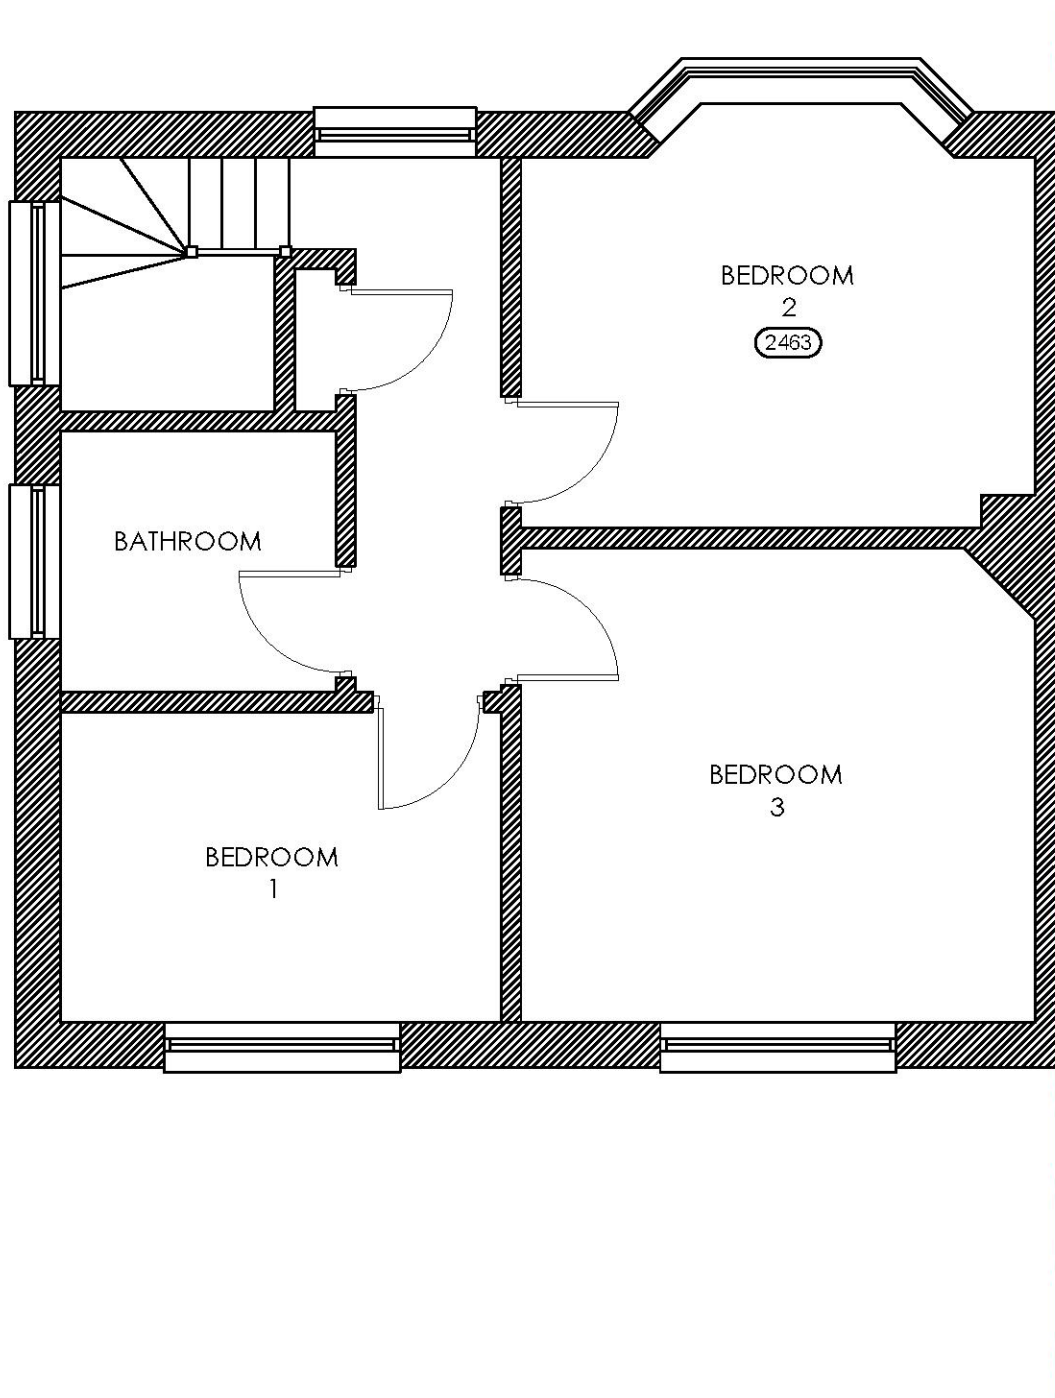

EXISTING FIRST FLOOR PLAN

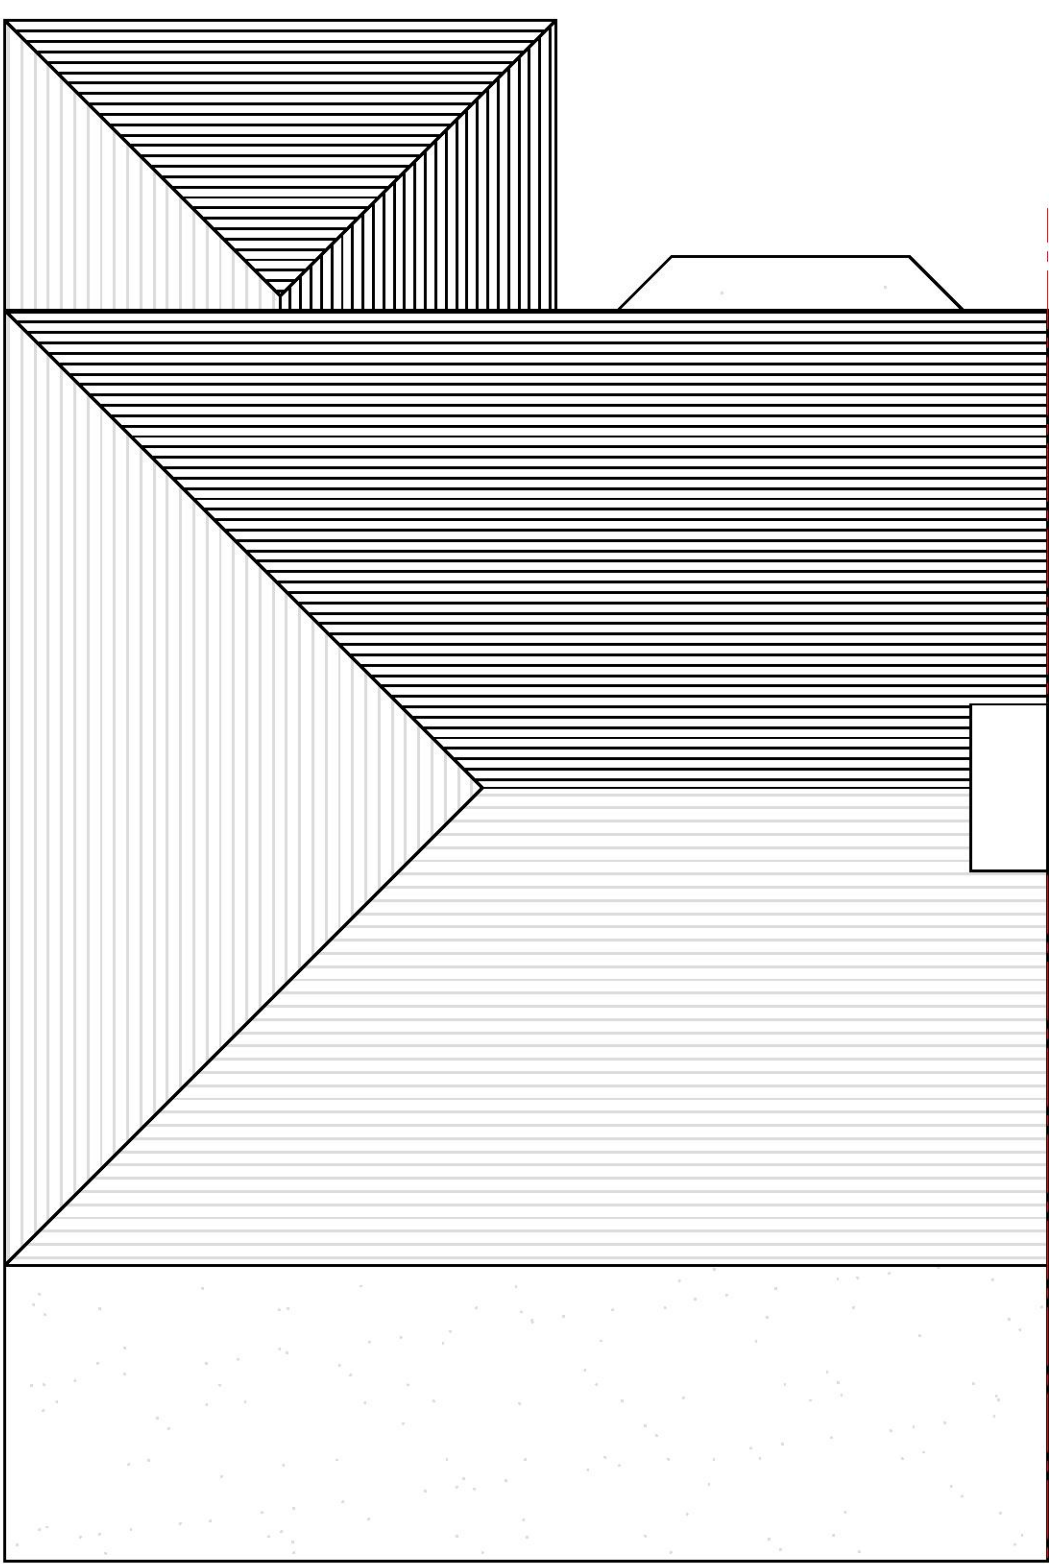

EXISTING ROOF PLAN

FLOOR PLANS KEYS


- GROUND GAS METER BOX
- ELECTRIC METER BOX
- EXTRACTOR FAN - COOKER HOOD
- EXTRACTOR FAN - WALL/CEILING MOUNTED
30 LITRES/SEC IN KITCHEN AND UTILITY ROOM
15 LITRES/SEC IN BATHROOM
6 LITRES/SEC IN WC
- SMOKE DETECTOR - MAINS OPERATED,
BATTERY BACK-UP
- HEAT DETECTOR - MAINS OPERATED,
BATTERY
- 30 MINUTES FIRE RESISTANT
- RAIN WATER PIPE
- SOIL WAST PIPE (snp - Vent pipe, SS
- Sub stack, AAV - Air admittance
valve)
- PROPOSED WALL / BRICK WORK
- PROPOSED WALL / BLOCK WORK
- PROPOSED ROOF
- DEMOLISHED
- INSULATION
- EXISTING WALL

NOTES:


SHORPLANS architects

Figured dimensions only are to be used. All dimensions to be checked on site. Differences between drawings and between drawings and specification or bills of quantities to be reported to SHORPLANS architects.

The copyright of the drawing and designs remains SHORPLANS architects.
All copies are only for information about the application, they may not be used for any other purpose without the express written permission of SHORPLANS architects.

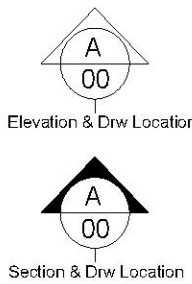

DRAWING NO	DATE	DRAWING	PROJECT
80-001	10.06.21	EXISTING PLANS	80 EYHURST AVENUE
DRAWN	SCALE		
LD	1:50 @ A1		

 




EXISTING FRONT ELEVATION



EXISTING RIGHT SIDE ELEVATION




EXISTING REAR ELEVATION

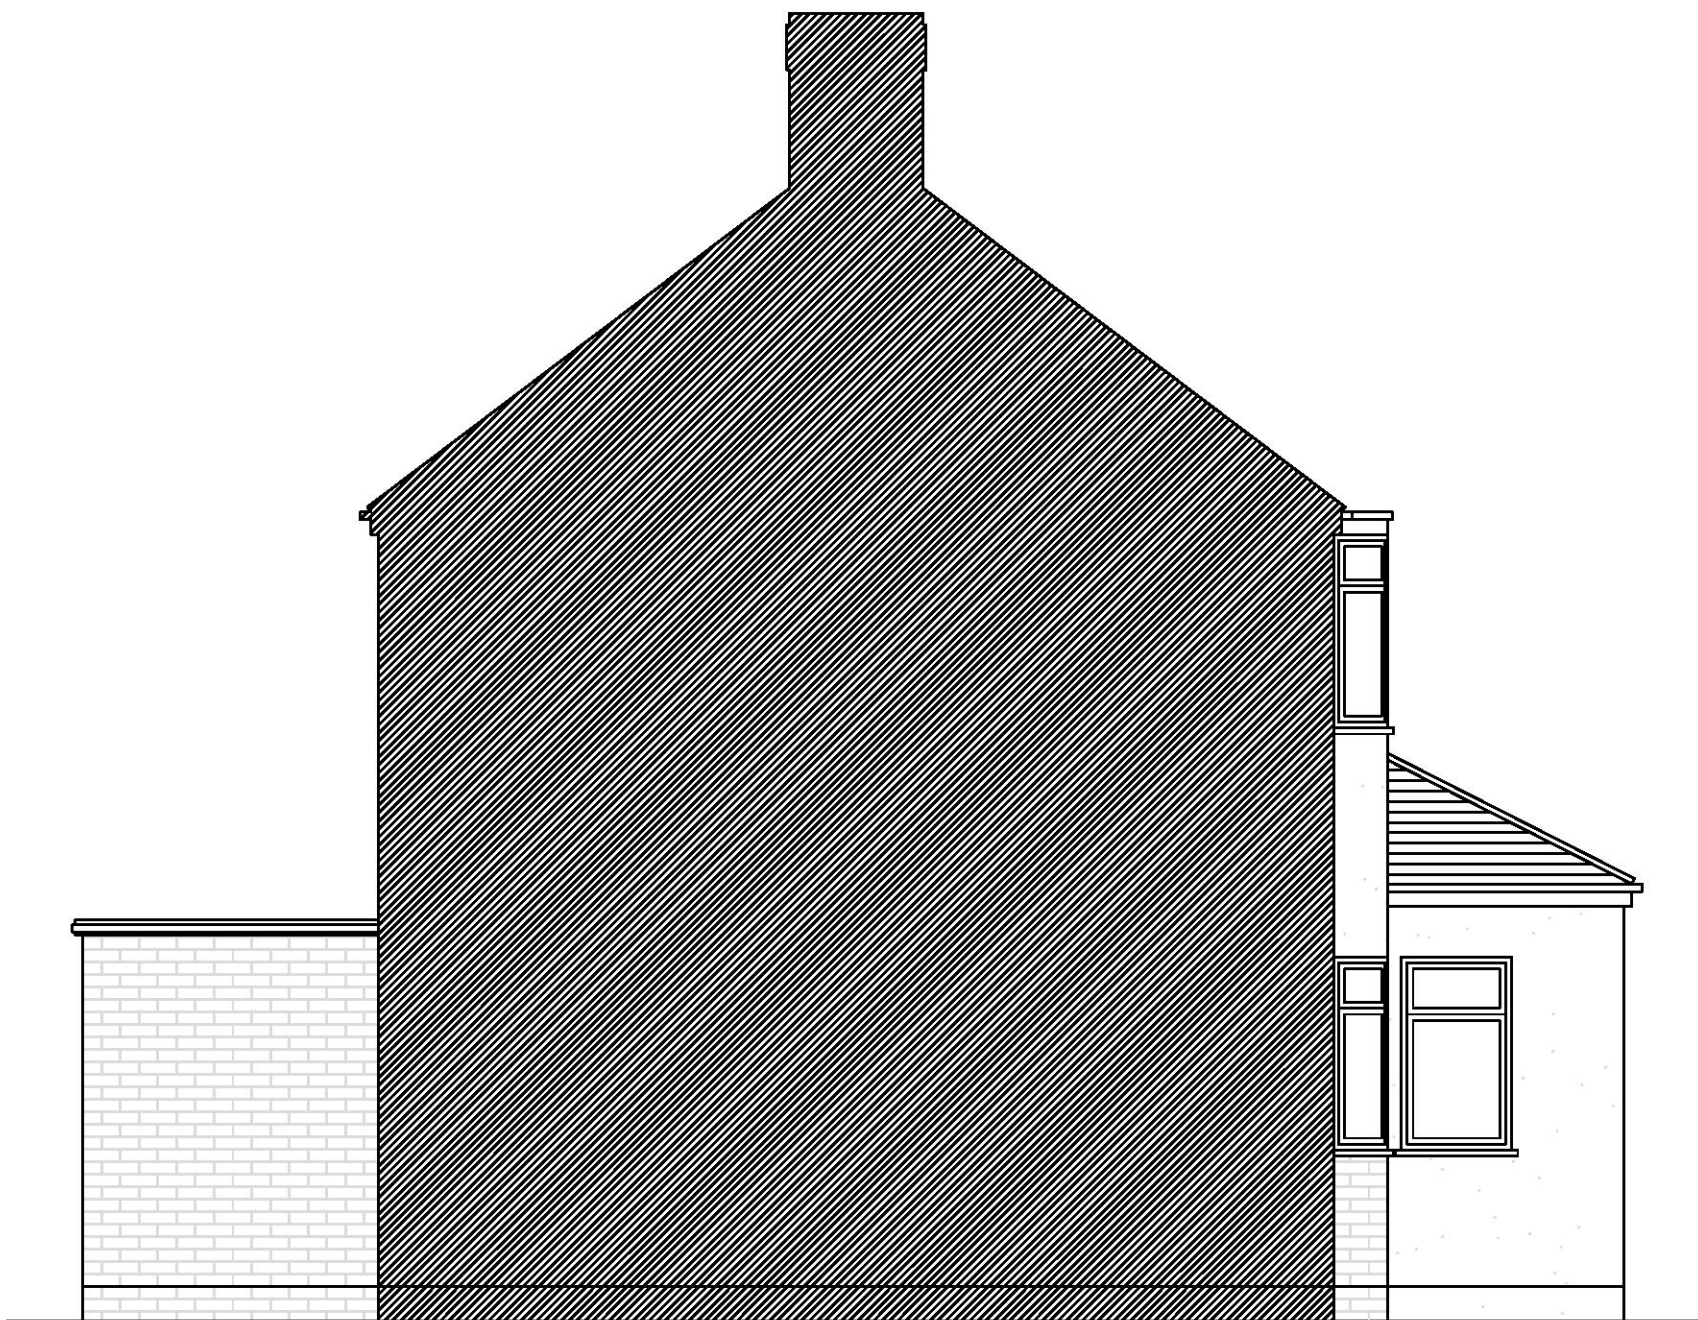

EXISTING LEFT SIDE ELEVATION




FLOOR PLANS KEYS

 - GROUND GAS METER BOX
- ELECTRIC METER BOX
- EXTRACTOR FAN - COOKER HOOD
- EXTRACTOR FAN - WALL/CEILING MOUNTED
30 LITRES/SEC IN KITCHEN AND UTILITY ROOM
15 LITRES/SEC IN BATHROOM
6 LITRES/SEC IN WC
- SMOKE DETECTOR - MAINS OPERATED,
BATTERY BACK-UP
- HEAT DETECTOR - MAINS OPERATED,
BATTERY
- 30 MINUTES FIRE RESISTANT
- RAIN WATER PIPE
- SOIL WAST PIPE (snp - Vent pipe, SS
- Sub stack, AAV - Air admittance
valve)
- PROPOSED WALL / BRICK WORK
- PROPOSED WALL / BLOCK WORK
- PROPOSED ROOF
- DEMOLISHED
- INSULATION
- EXISTING WALL



02 EXISTING ELEVATIONS
SCALE 1:50 @ A1

DRAWING NO	DATE	DRAWING	PROJECT
80-002	10.06.21	EXISTING ELEVATIONS	80 EYHURST AVENUE
DRAWN	SCALE		
LD	1:50 @ A1		

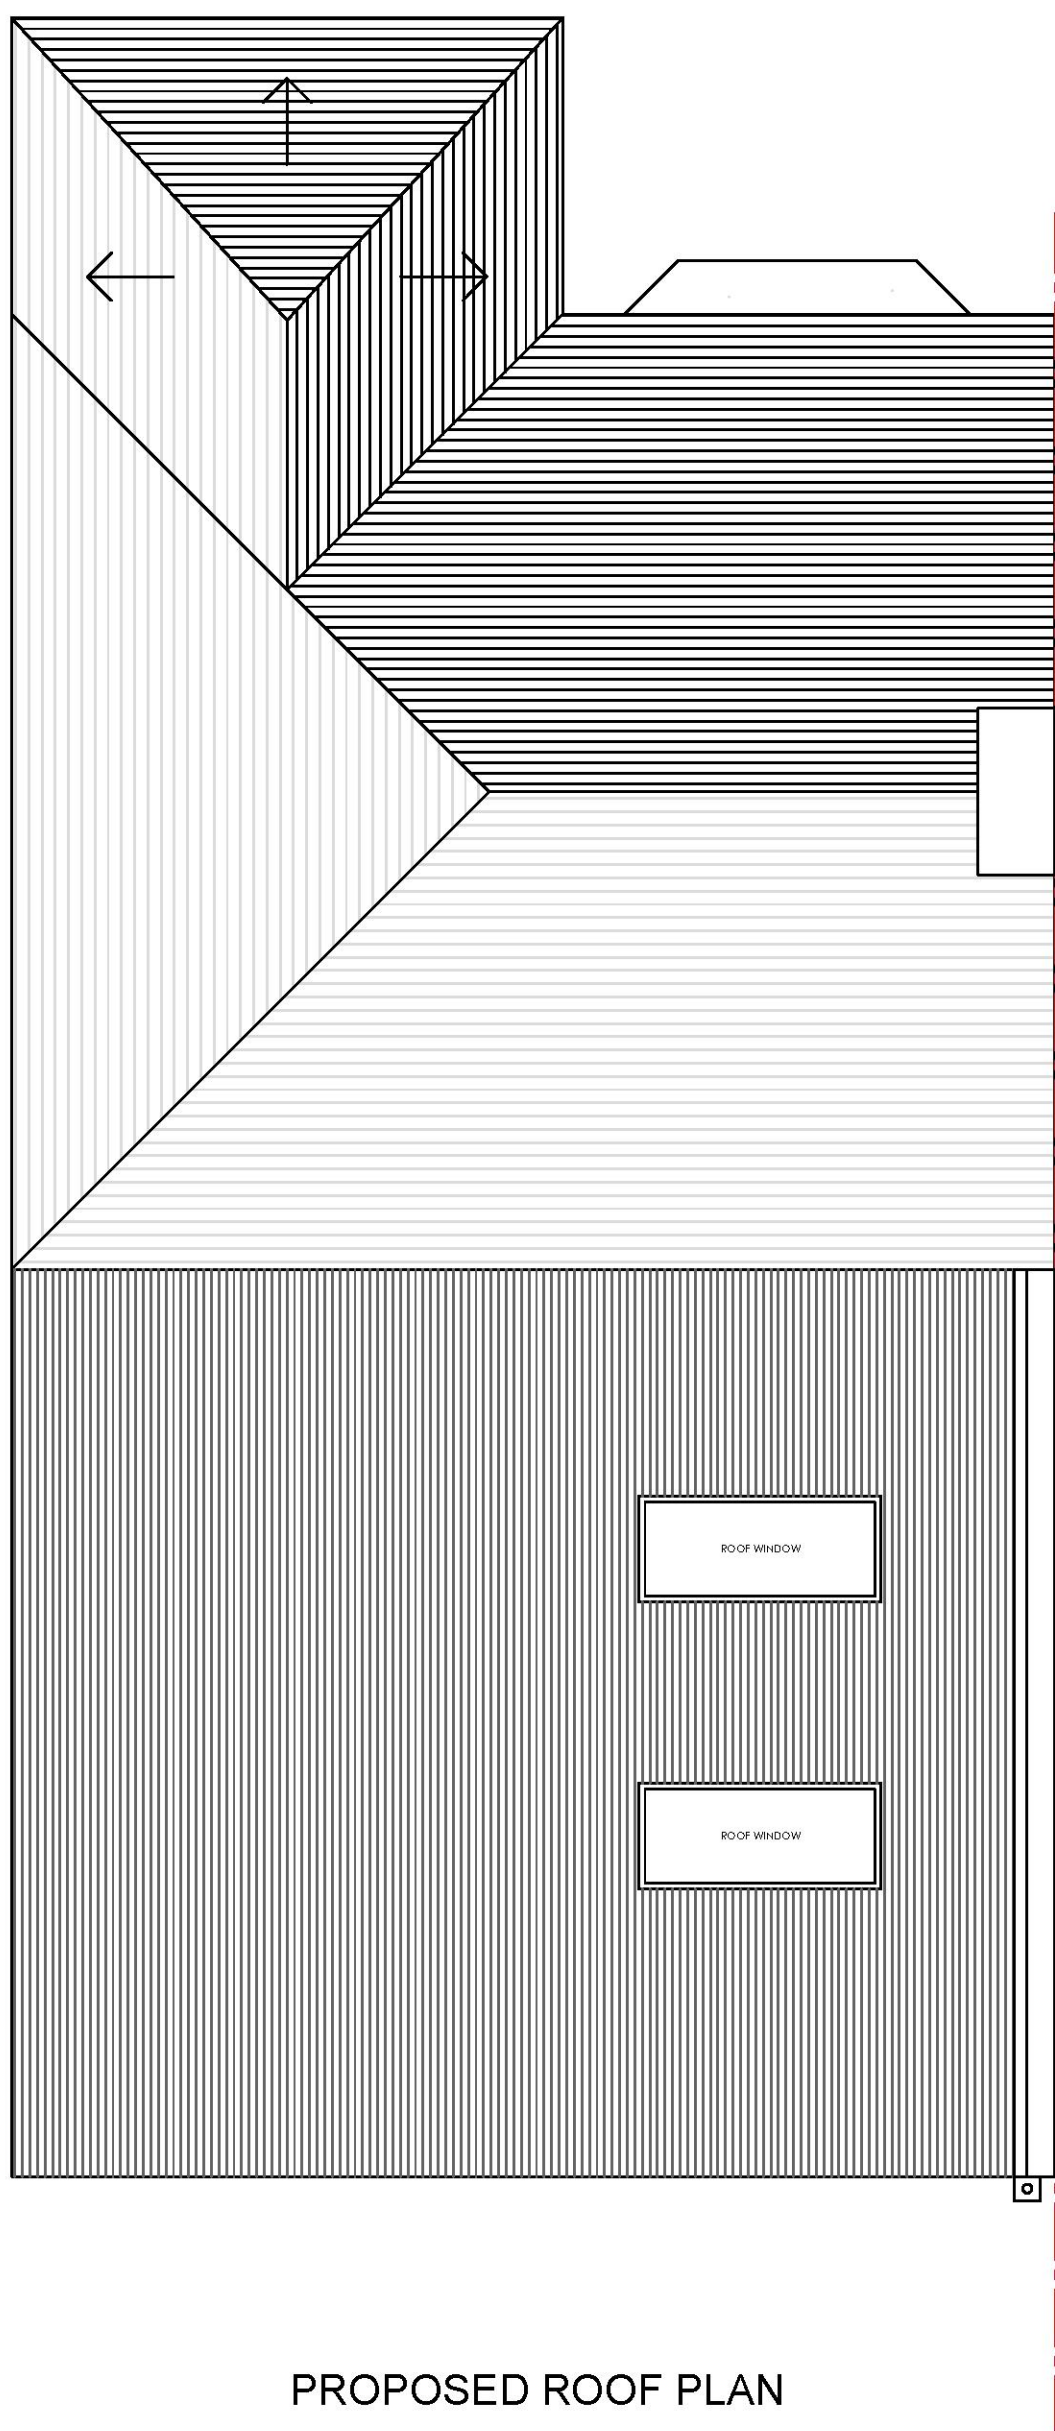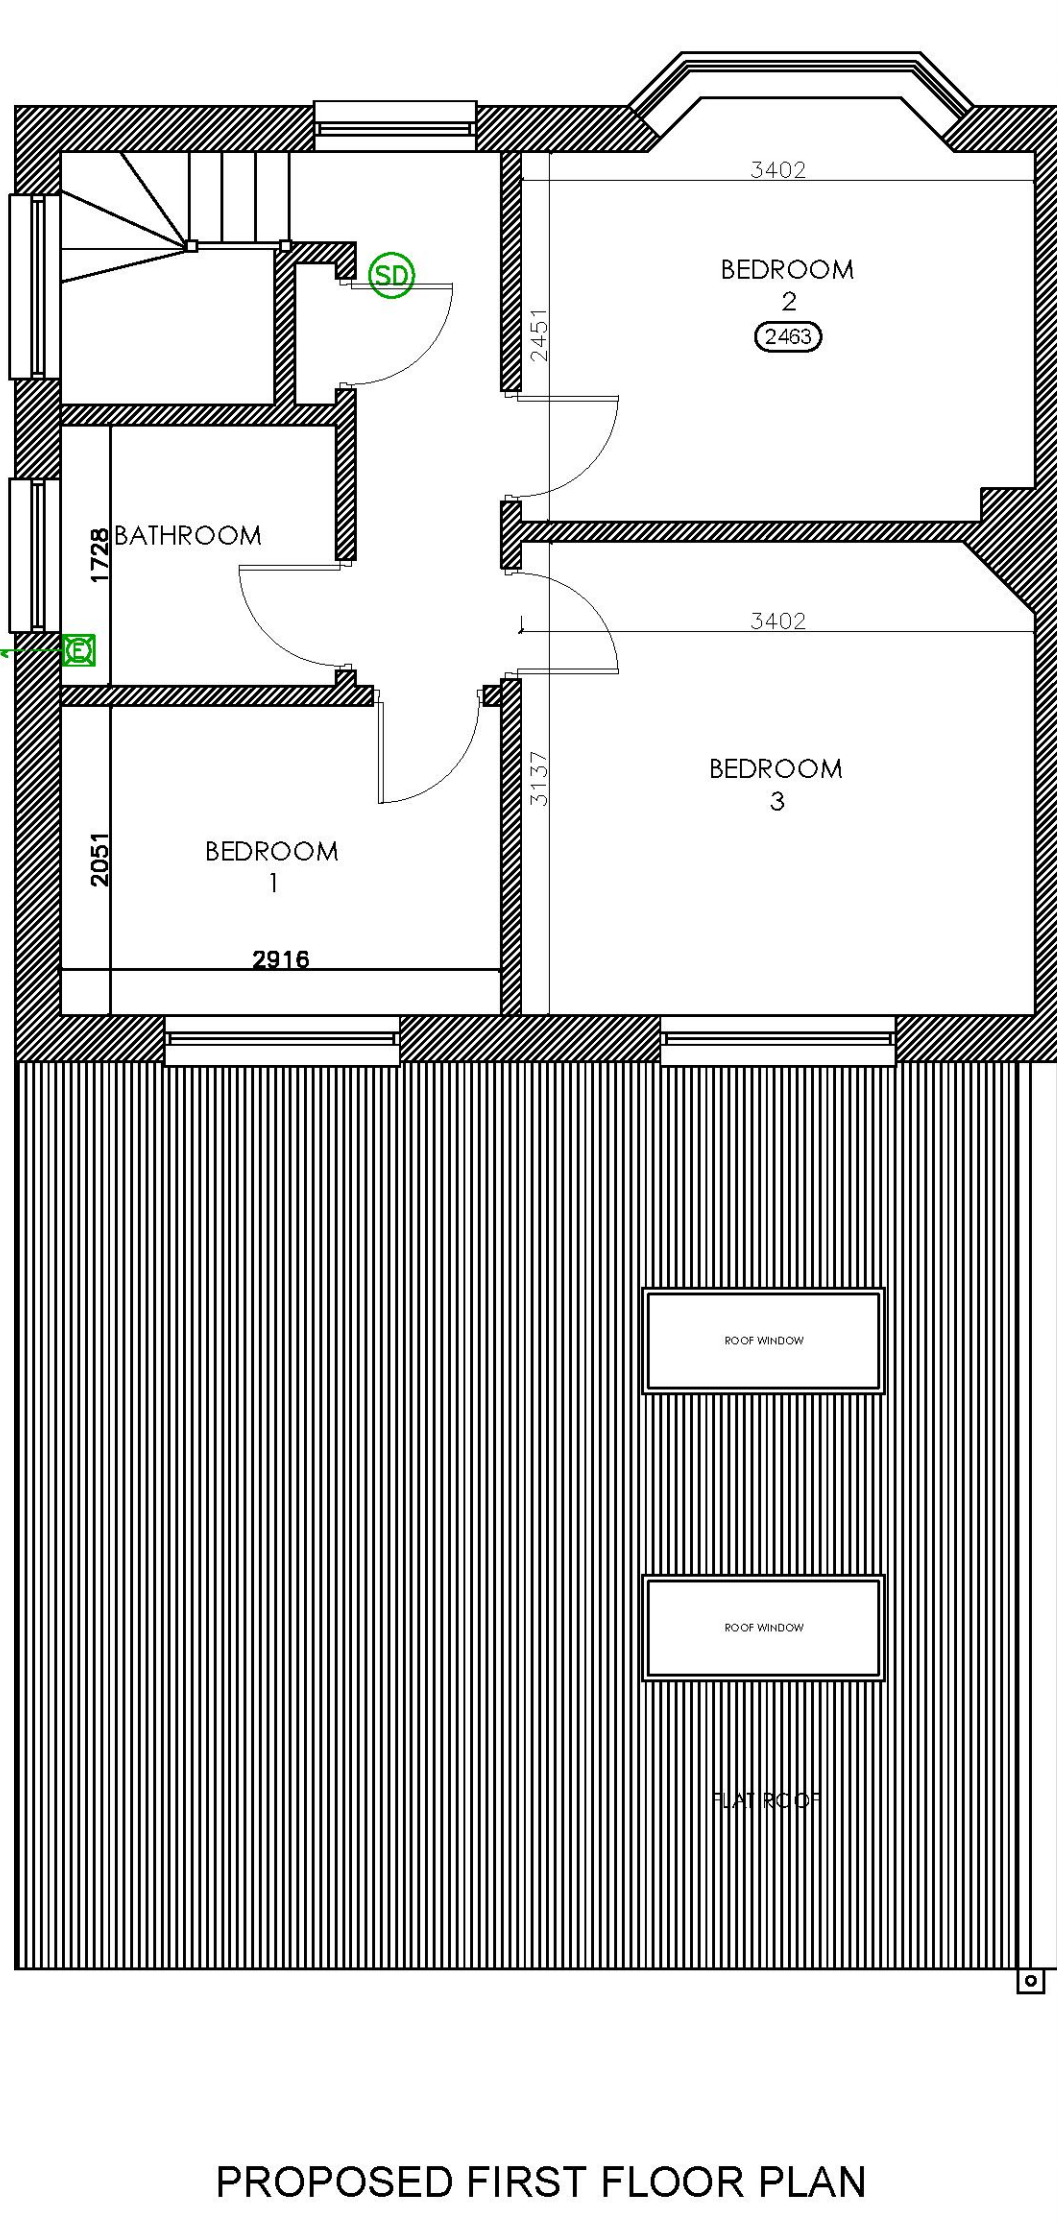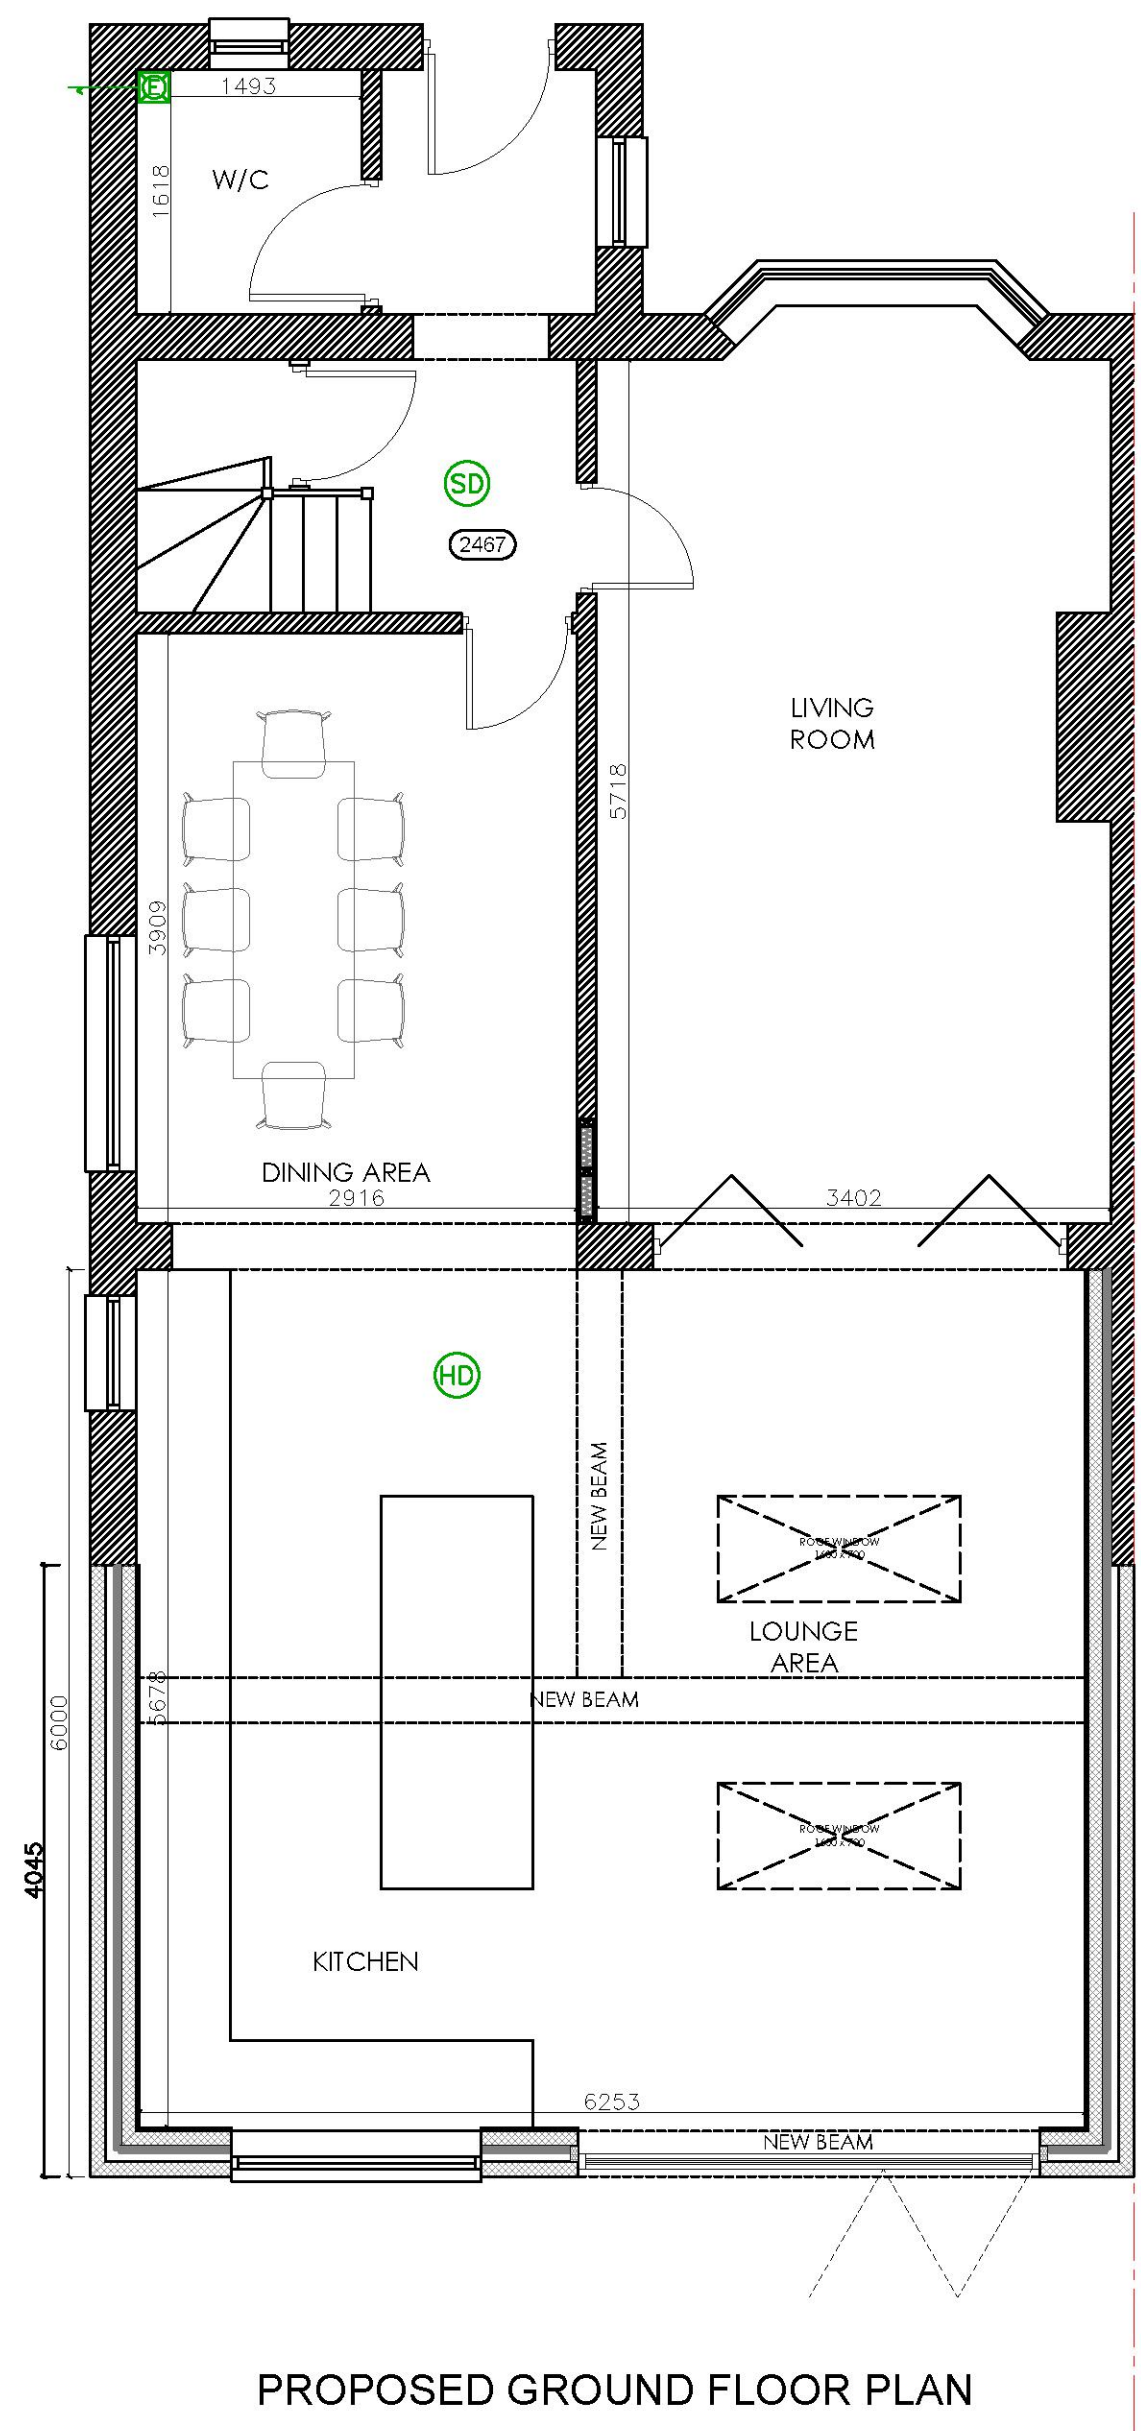

FLOOR PLANS KEYS

 
- GROUND GAS METER BOX
- ELECTRIC METER BOX
- EXTRACTOR FAN - COOKER HOOD
- EXTRACTOR FAN - WALL/CEILING MOUNTED
30 LITRES/SEC IN KITCHEN AND UTILITY ROOM
15 LITRES/SEC IN BATHROOM
6 LITRES/SEC IN W/C
- SMOKE DETECTOR - MAINS OPERATED,
BATTERY BACK-UP
- HEAT DETECTOR - MAINS OPERATED,
BATTERY
- 30 MINUTES FIRE RESISTANT
- RAIN WATER PIPE
- SOIL WAST PIPE (snp - Vent pipe, SS
- Stub stack, AAV - Air admittance
valve)
- PROPOSED WALL / BRICK WORK
- PROPOSED WALL / BLOCK WORK
- PROPOSED ROOF
- DEMOLISHED
- INSULATION
- EXISTING WALL
- WATER POINT (POSITION/HEIGHT TBC)
- GAS OUTLET FOR STOVE (POSITION/HEIGHT TBC)
- DOUBLE SWITCHED WALL SOCKET
- TRIPLE SWITCHED FLOOR SOCKET
- LIGHT POINT DOWNLIGHTER/PENDANT HOLDER
(POSITION TBC ON SITE)

03 PROPOSED PLANS
SCALE 1:50 @ A1

SHORPLANS
ARCHITECTURAL SERVICES

17-21 GEORGE STREET
CROYDON, SURREY
CR0 1LA

WWW.SHORPLANS.COM
ADMIN@SHORPLANS.COM
020 38806164


RIBA 
Chartered Practice

NOTES:

SHORPLANS architects

Figured dimensions only are to be used. All dimensions to be checked on site. Differences between drawings and between drawings and specification or bills of quantities to be reported to SHORPLANS architects.

The copyright of the drawing and designs remains SHORPLANS architects.
All copies are only for information about the application, they may not be used for any other purpose without the express written permission of SHORPLANS architects.

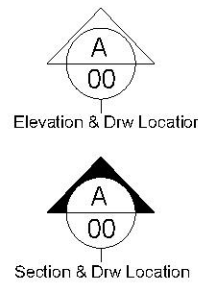

DRAWING NO	DATE	DRAWING	PROJECT
80-003	10.06.21	PROPOSED PLANS	80 EYHURST AVENUE
DRAWN	SCALE		
LD	1:50 @ A1		




EXISTING FRONT ELEVATION



PROPOSED RIGHT SIDE ELEVATION



PROPOSED REAR ELEVATION

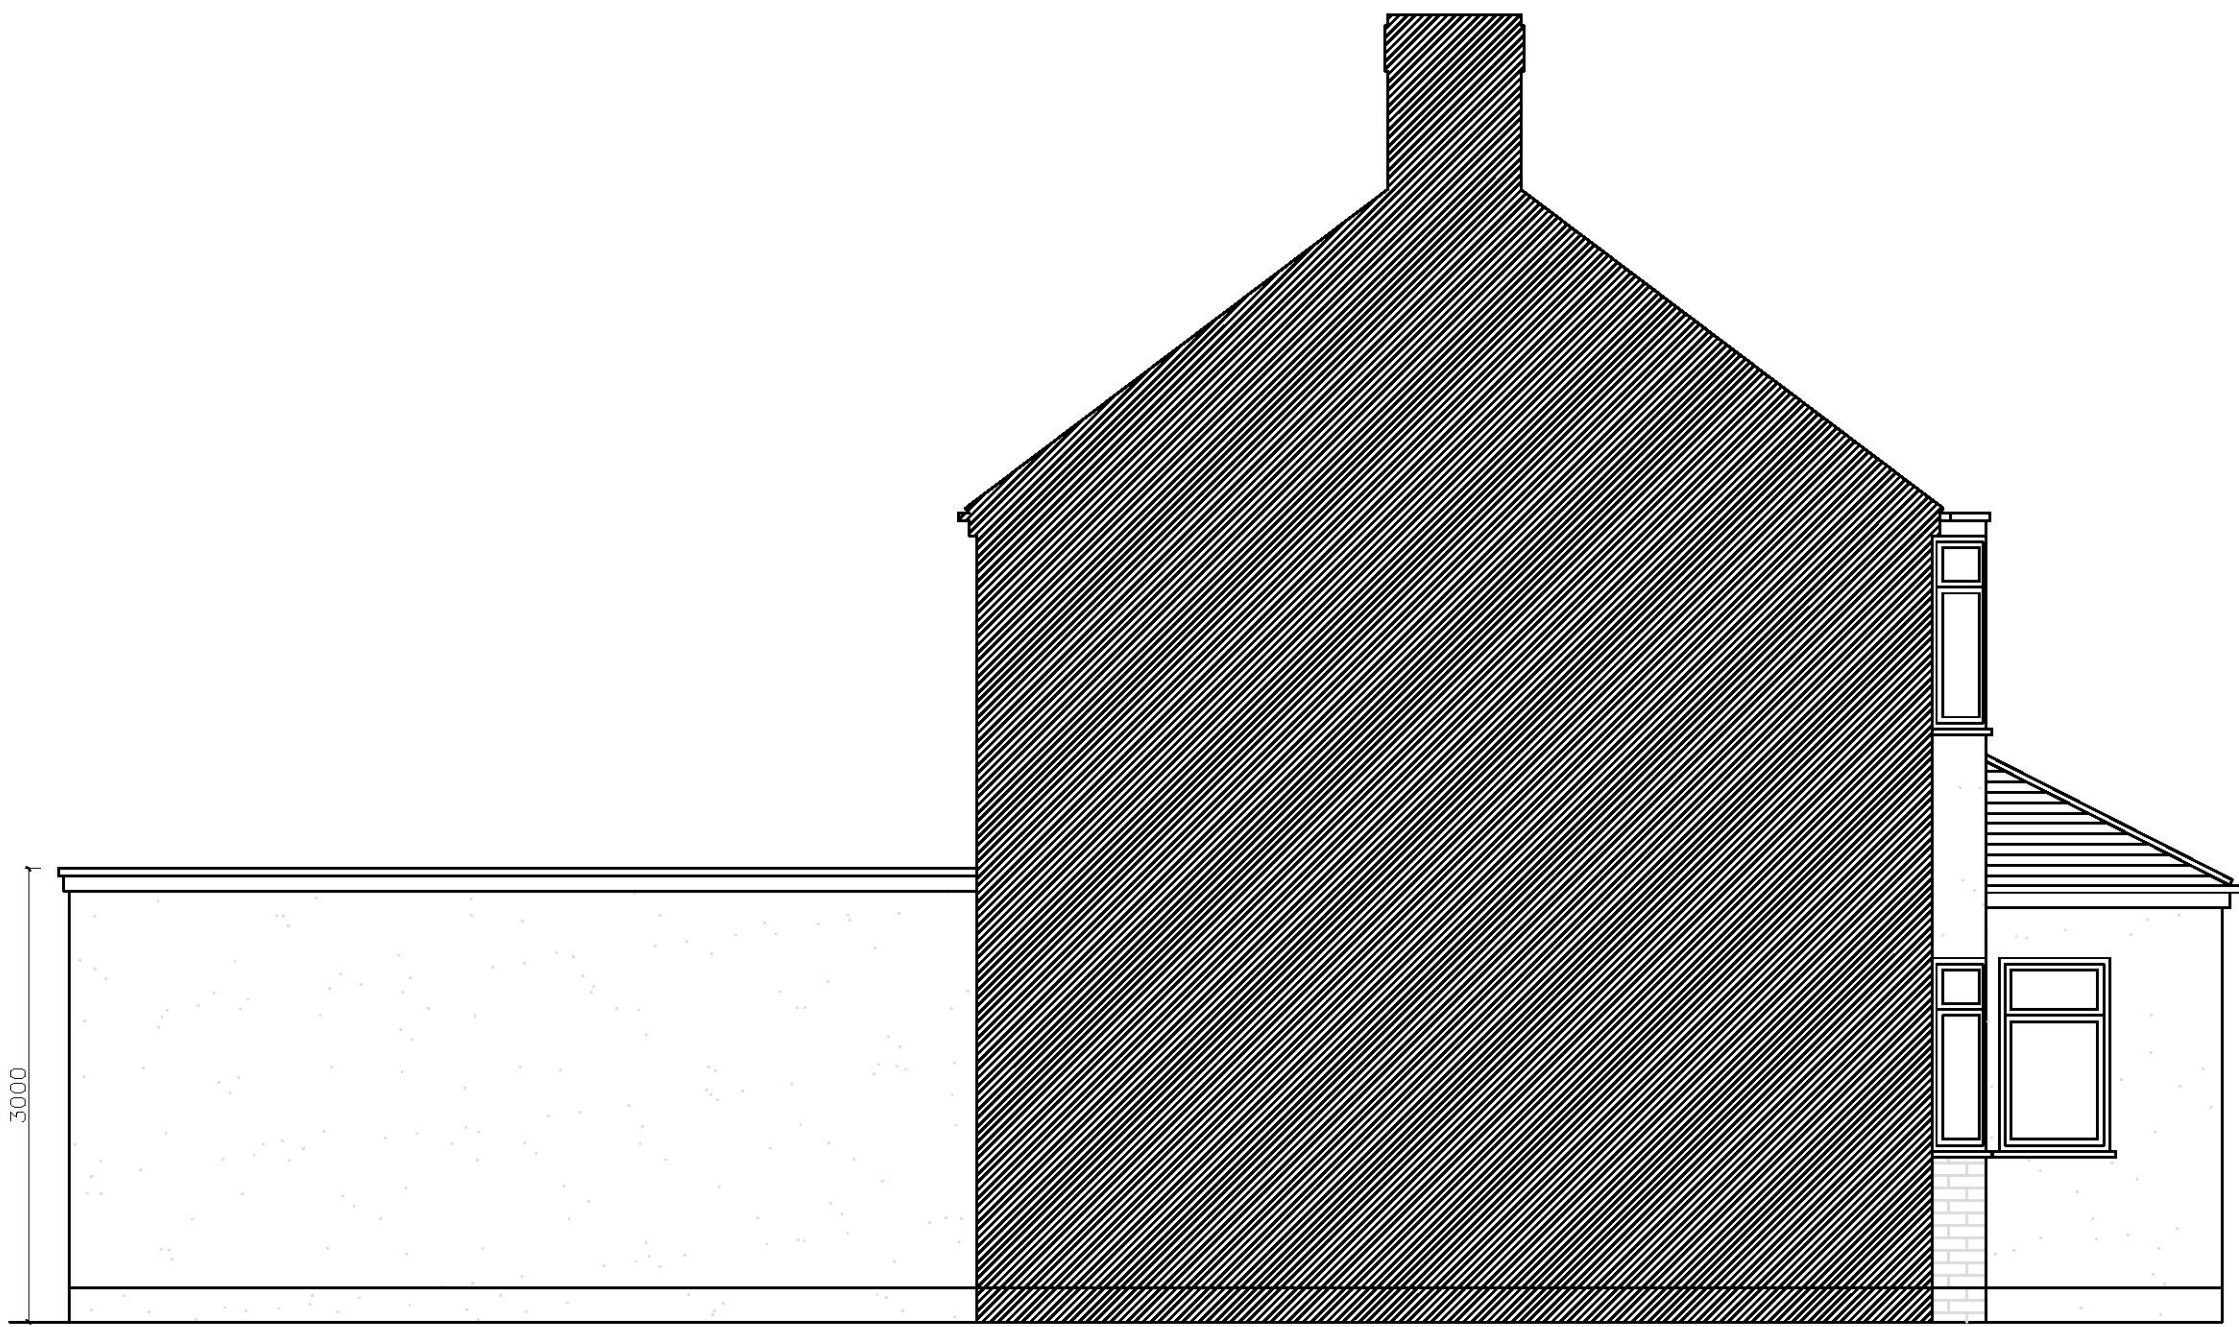

PROPOSED LEFT SIDE ELEVATION

FLOOR PLANS KEYS

- GROUND GAS METER BOX
- ELECTRIC METER BOX
- EXTRACTOR FAN - COOKER HOOD
- EXTRACTOR FAN - WALL/CEILING MOUNTED
30 LITRES/SEC IN KITCHEN AND UTILITY ROOM
15 LITRES/SEC IN BATHROOM
6 LITRES/SEC IN WC
- SMOKE DETECTOR - MAINS OPERATED,
BATTERY BACK-UP
- HEAT DETECTOR - MAINS OPERATED,
BATTERY
- 30 MINUTES FIRE RESISTANT
- RAIN WATER PIPE
- SOIL WAST PIPE (snp - Vent pipe, SS
- Sub stack, AAV - Air admittance
valve)
- PROPOSED WALL / BRICK WORK
- PROPOSED WALL / BLOCK WORK
- PROPOSED ROOF
- DEMOLISHED
- INSULATION
- EXISTING WALL