




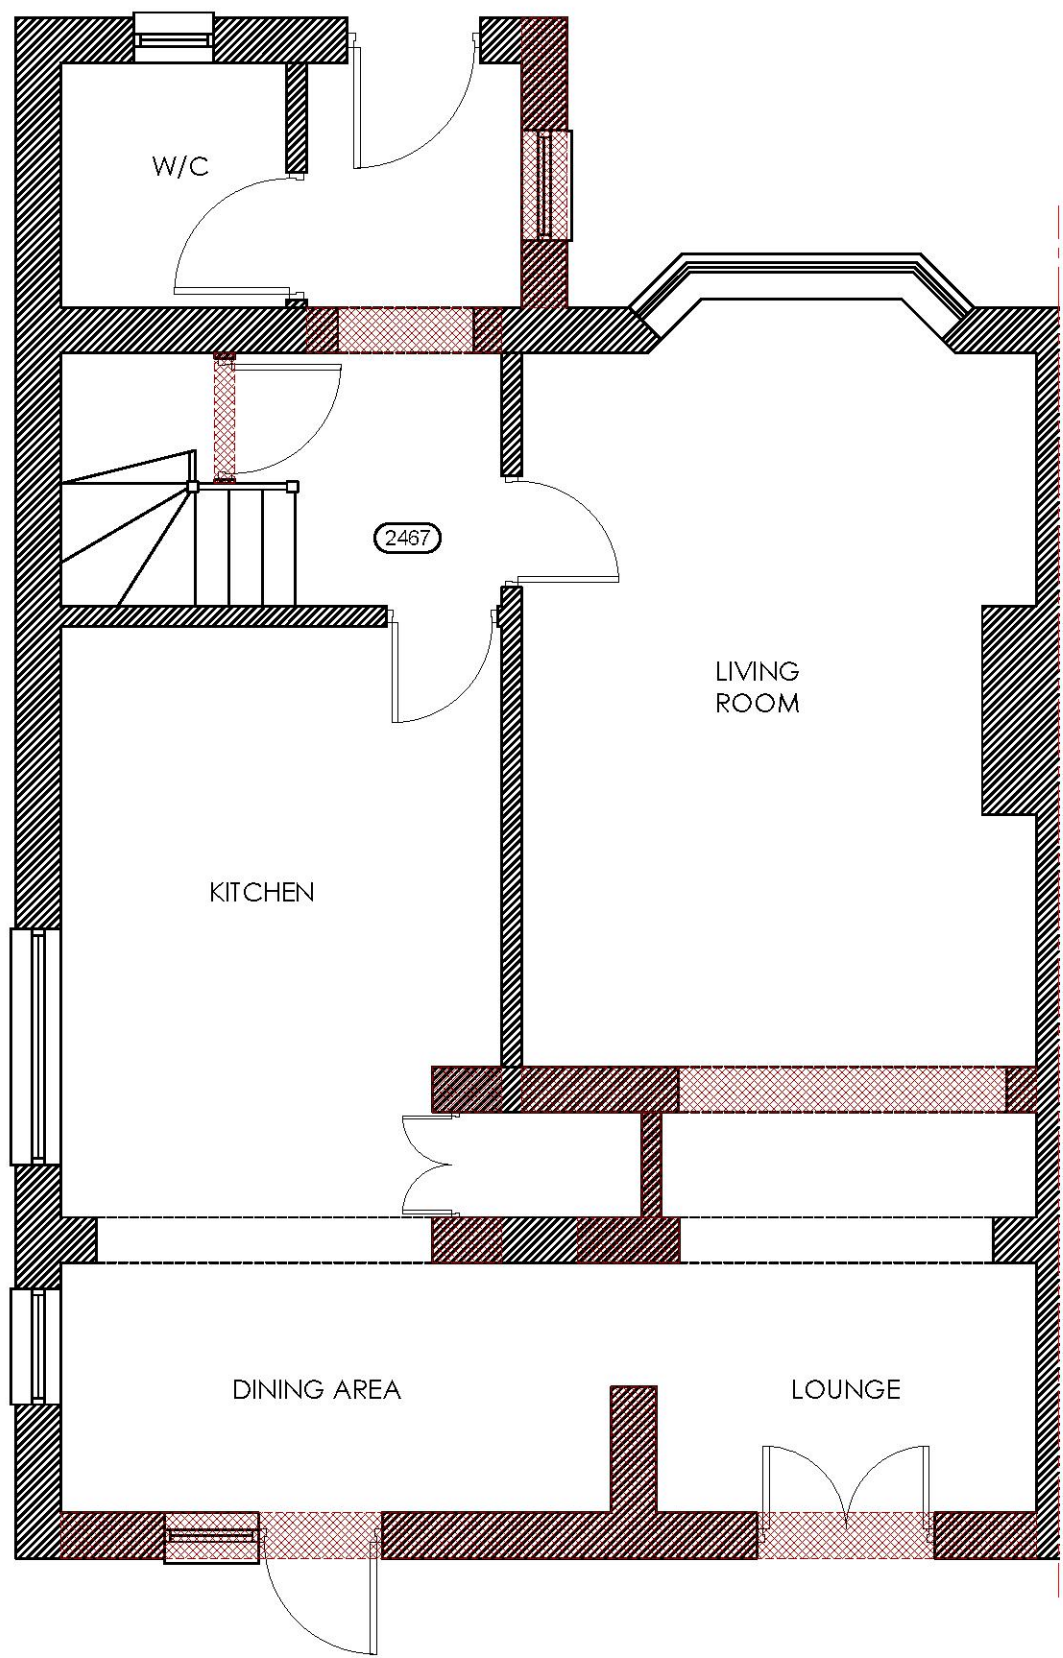

EXISTING GROUND FLOOR PLAN

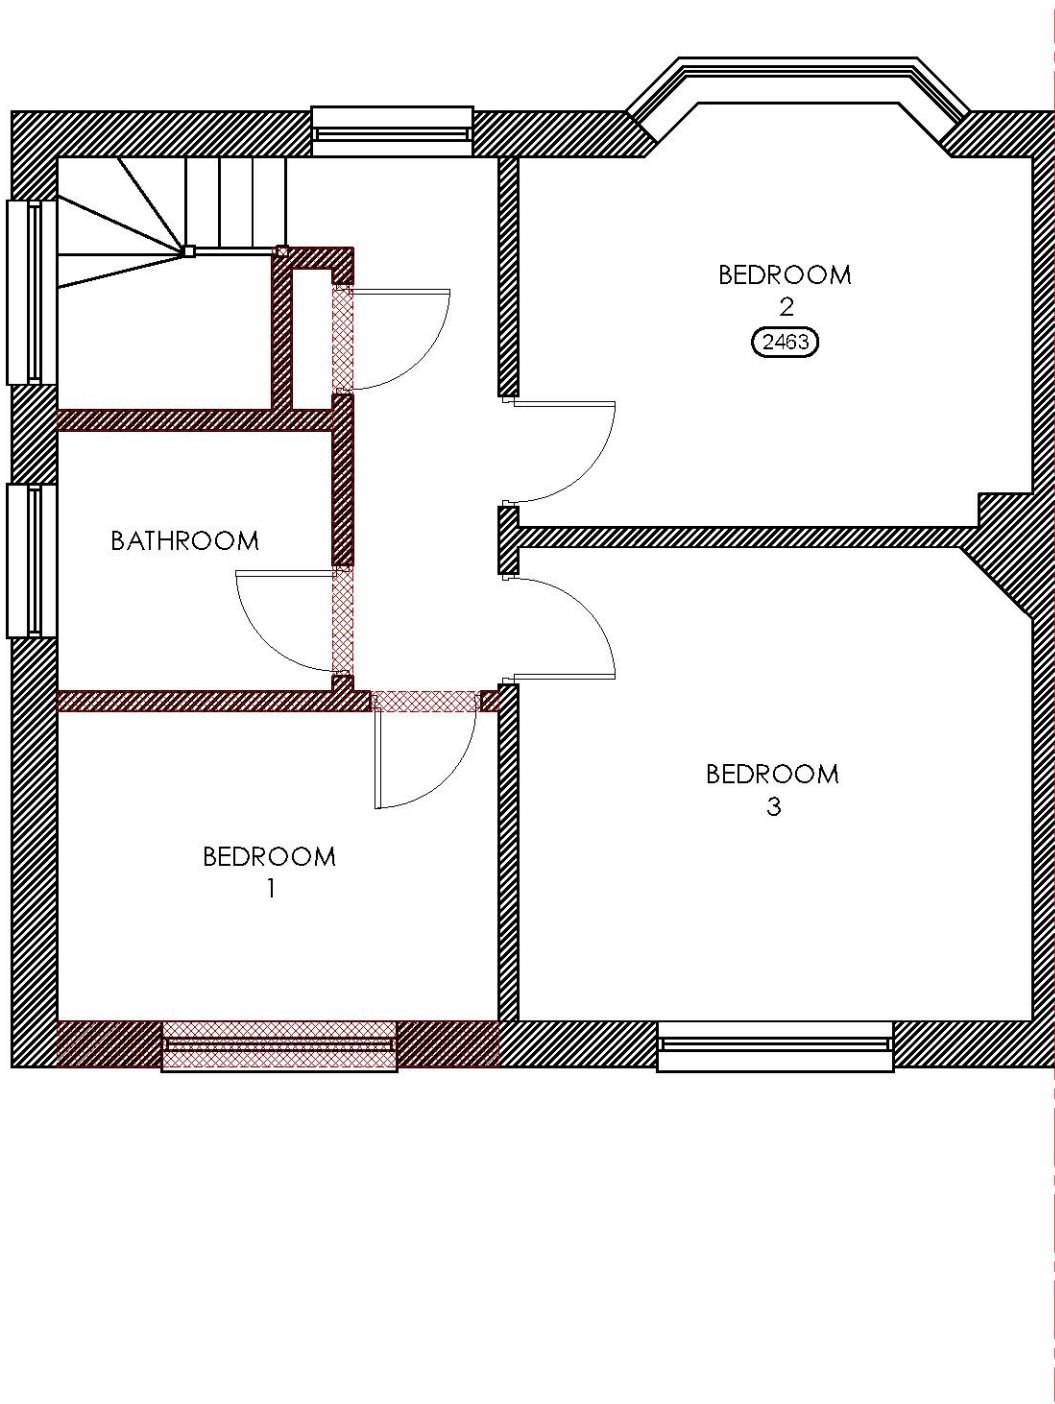

 
EXISTING FIRST FLOOR PLAN

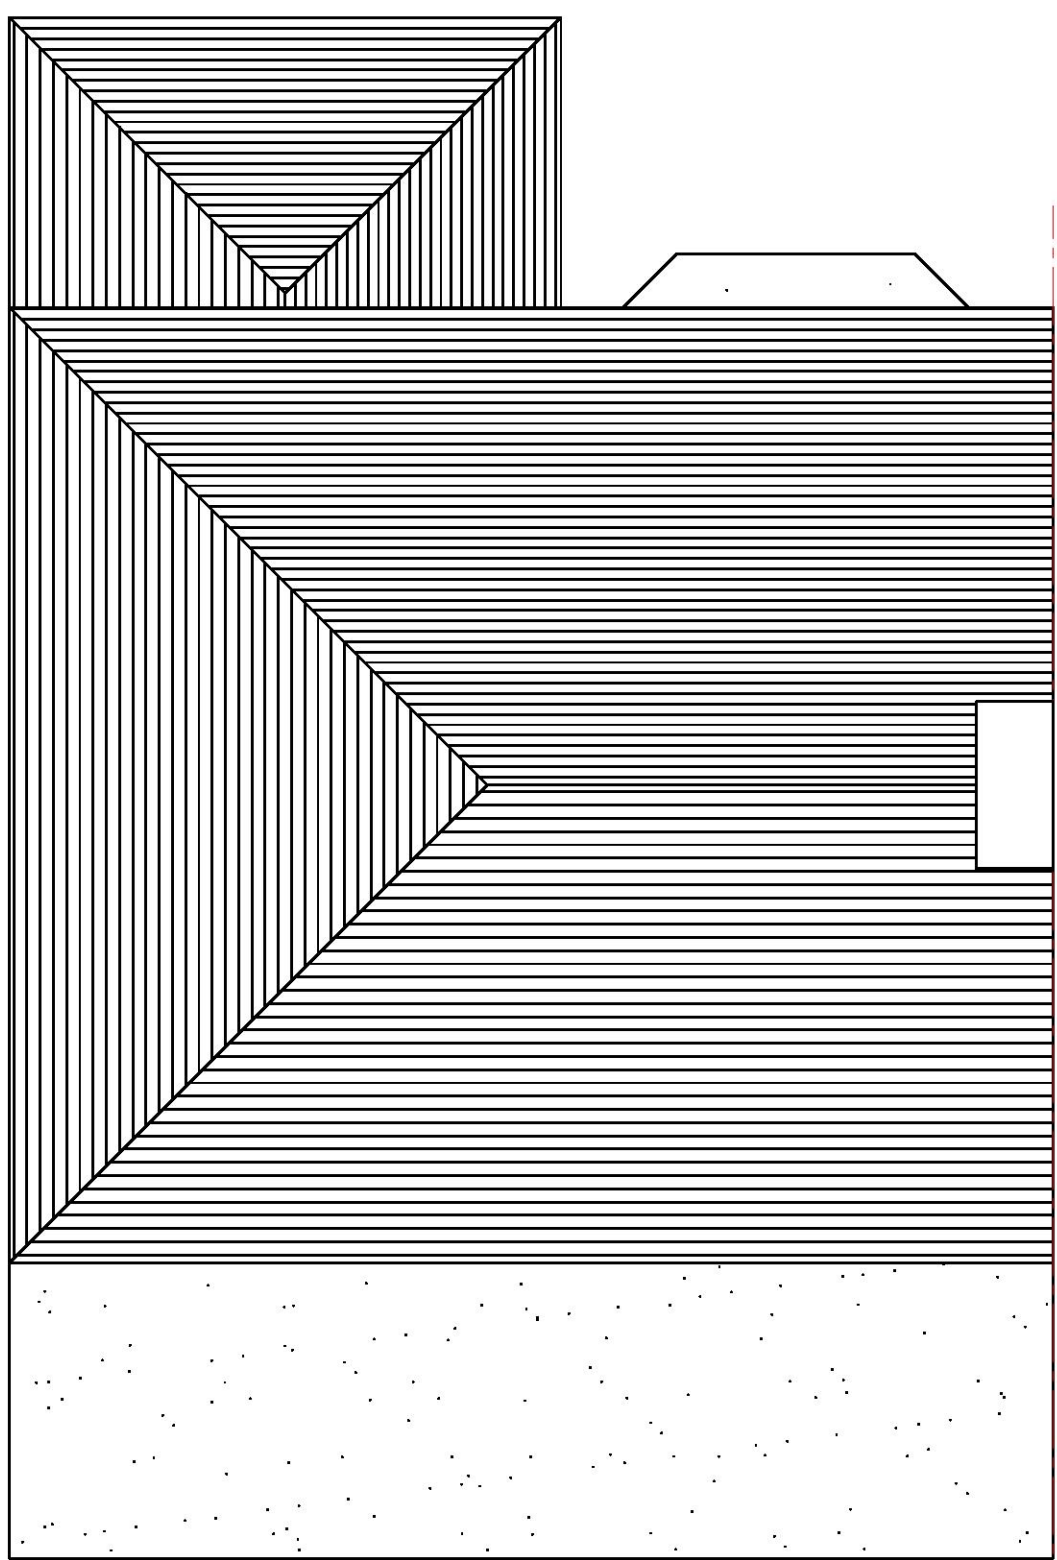

EXISTING ROOF PLAN


FLOOR PLANS KEYS

- GROUND GAS METER BOX
- ELECTRIC METER BOX
- EXTRACTOR FAN - COOKER HOOD
- EXTRACTOR FAN - WALL/CEILING MOUNTED
30 LITRES/SEC IN KITCHEN AND UTILITY ROOM
15 LITRES/SEC IN BATHROOM
6 LITRES/SEC IN WC
- SMOKE DETECTOR - MAINS OPERATED, BATTERY BACK-UP
- HEAT DETECTOR - MAINS OPERATED, BATTERY
- 30 MINUTES FIRE RESISTANT
- RAIN WATER PIPE
- SOIL WAST PIPE (snp - Vent pipe, SS - Sub stack, AAV - Air admittance valve)
- PROPOSED WALL / BRICK WORK
- PROPOSED WALL / BLOCK WORK
- PROPOSED ROOF
- DEMOLISHED
- INSULATION
- EXISTING WALL




01 EXISTING PLANS
SCALE 1:50 @ A1


DRAWING NO	DATE	DRAWING	PROJECT
80-001	27.09.21	EXISTING PLANS	80 EYHURST AVENUE
DRAWN	SCALE		
LD	1:50 @ A1		

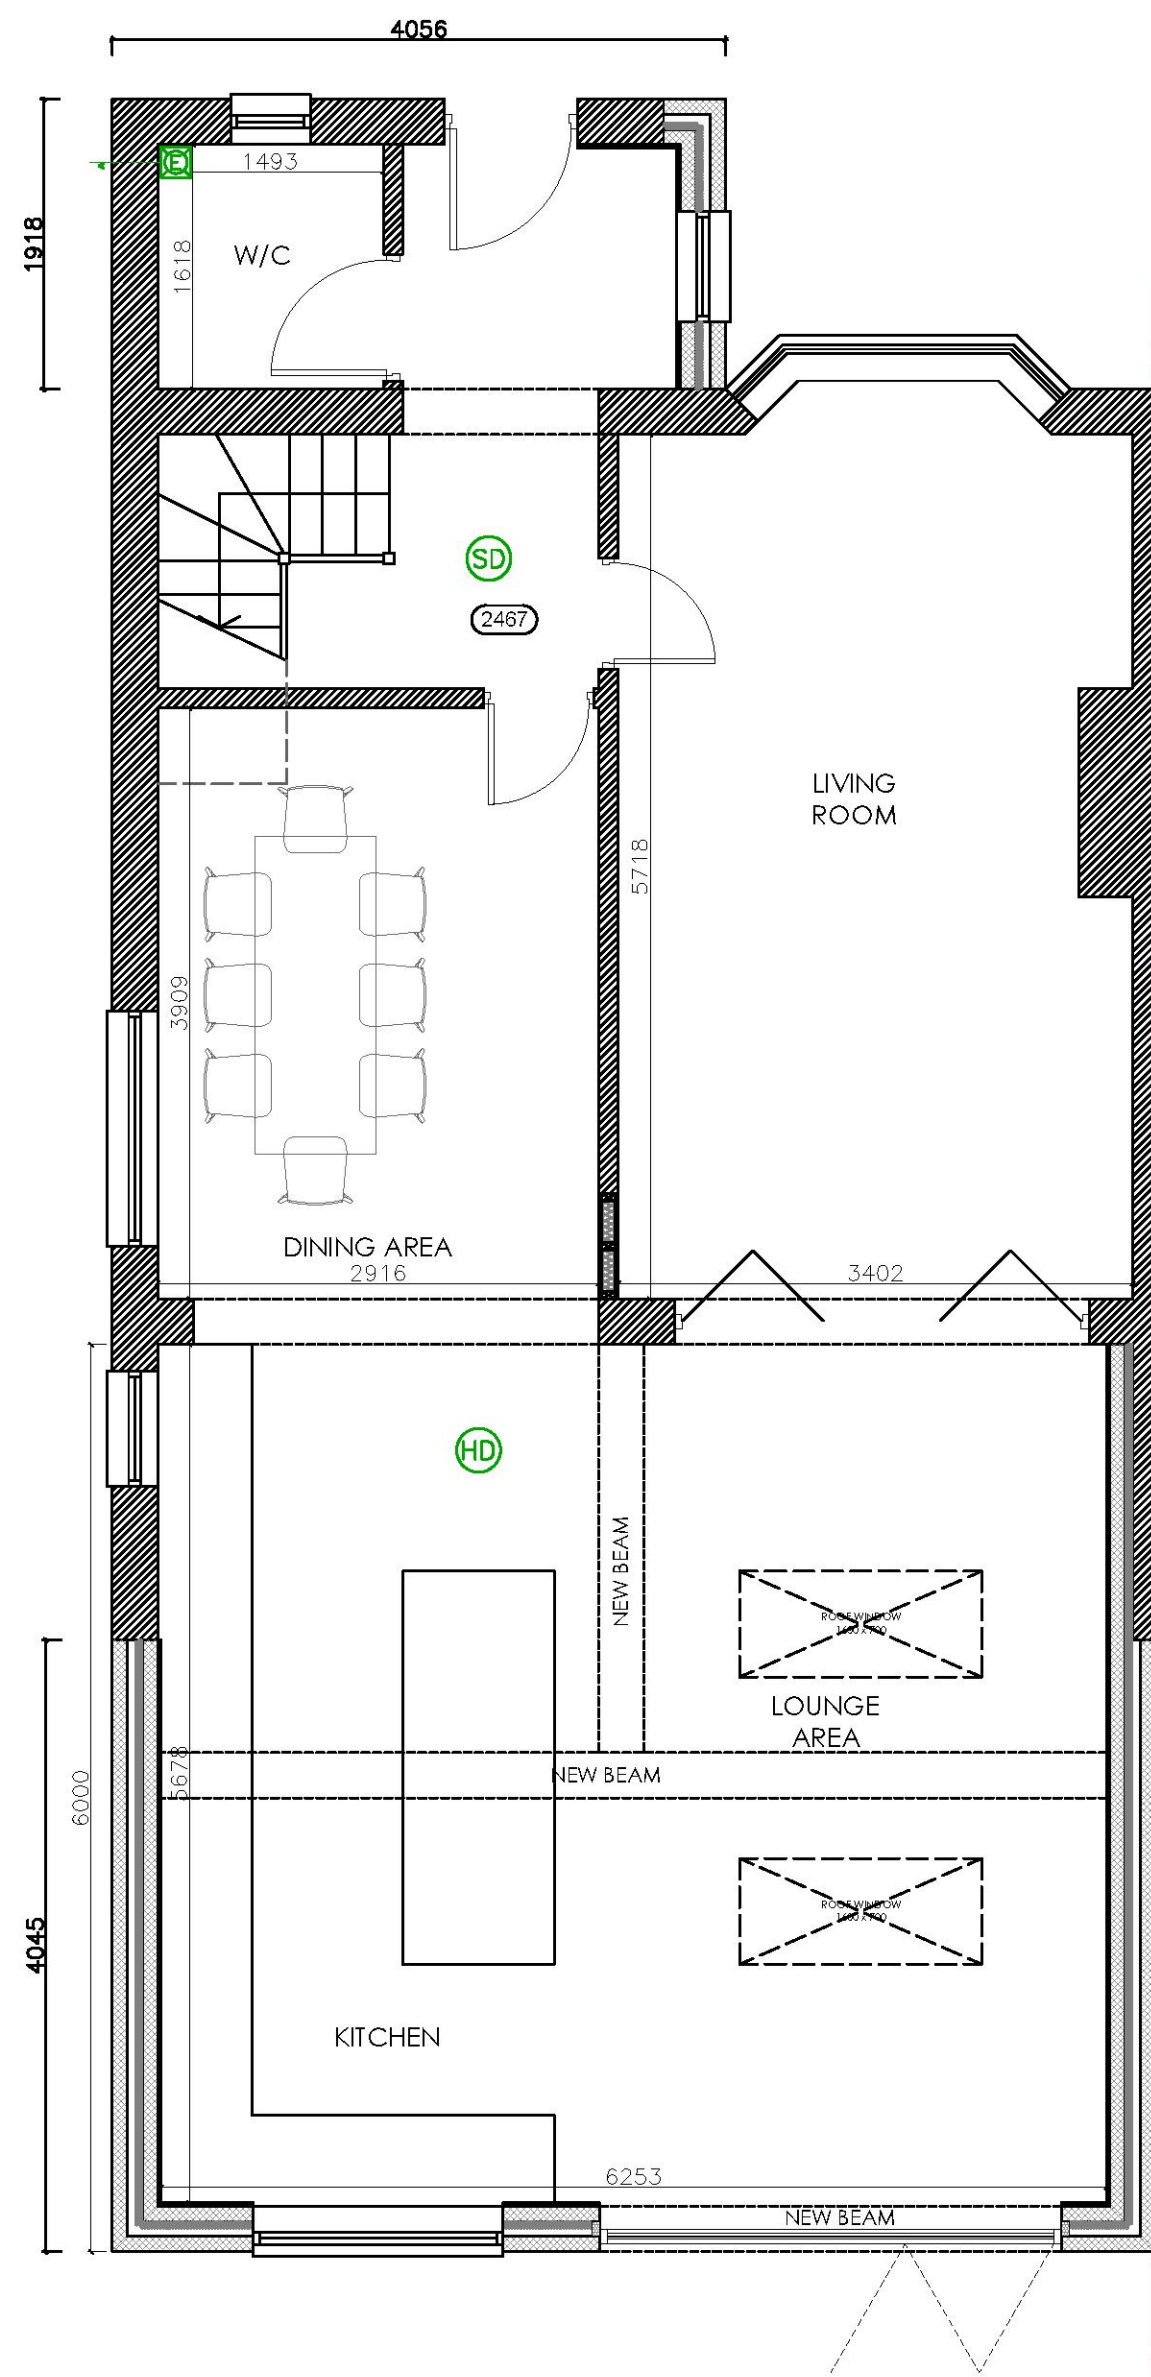

PROPOSED GROUND FLOOR PLAN

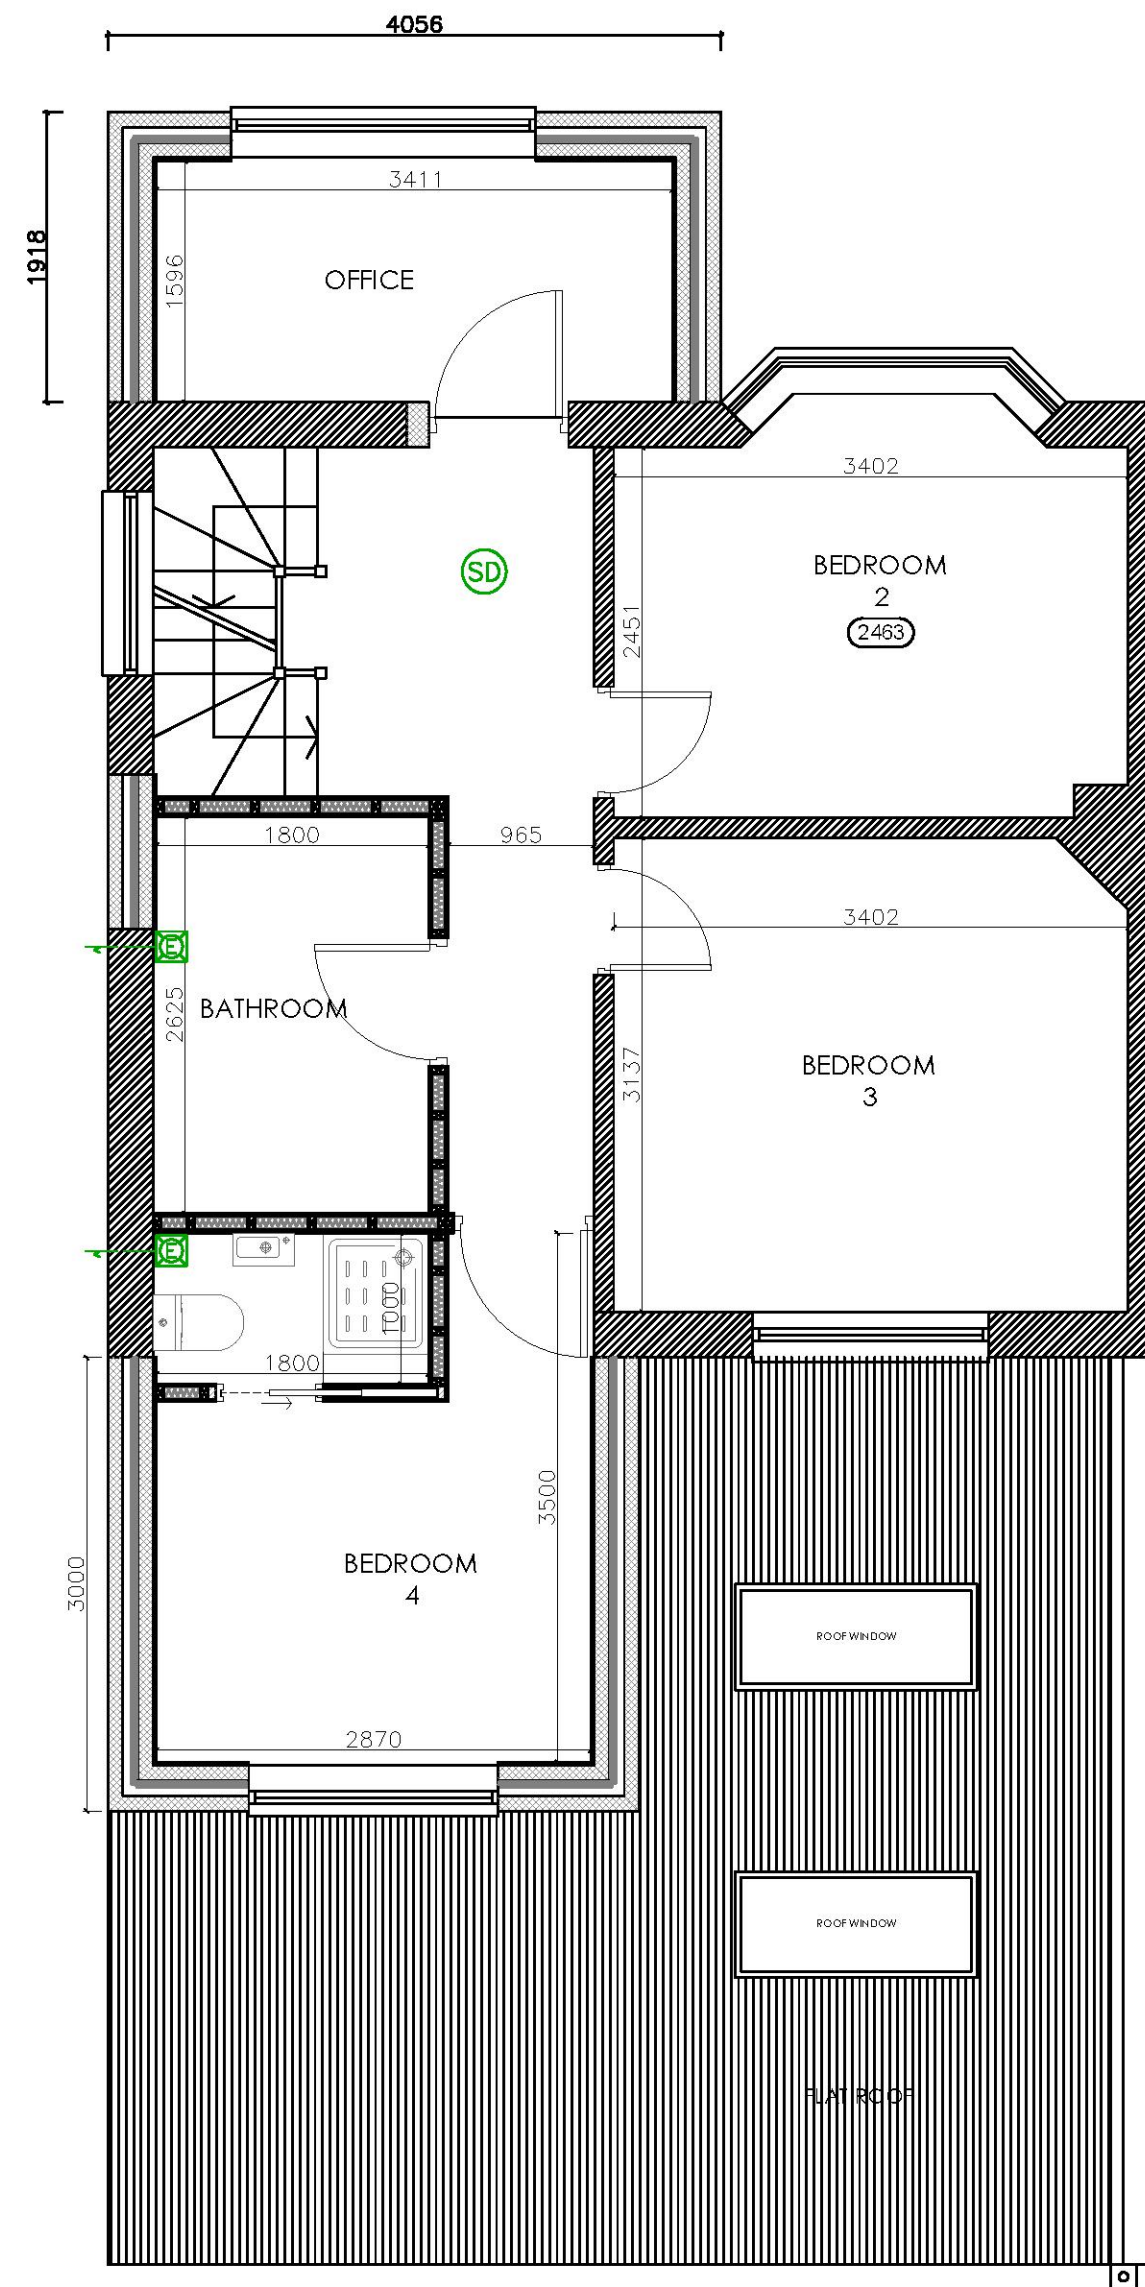

PROPOSED FIRST FLOOR PLAN

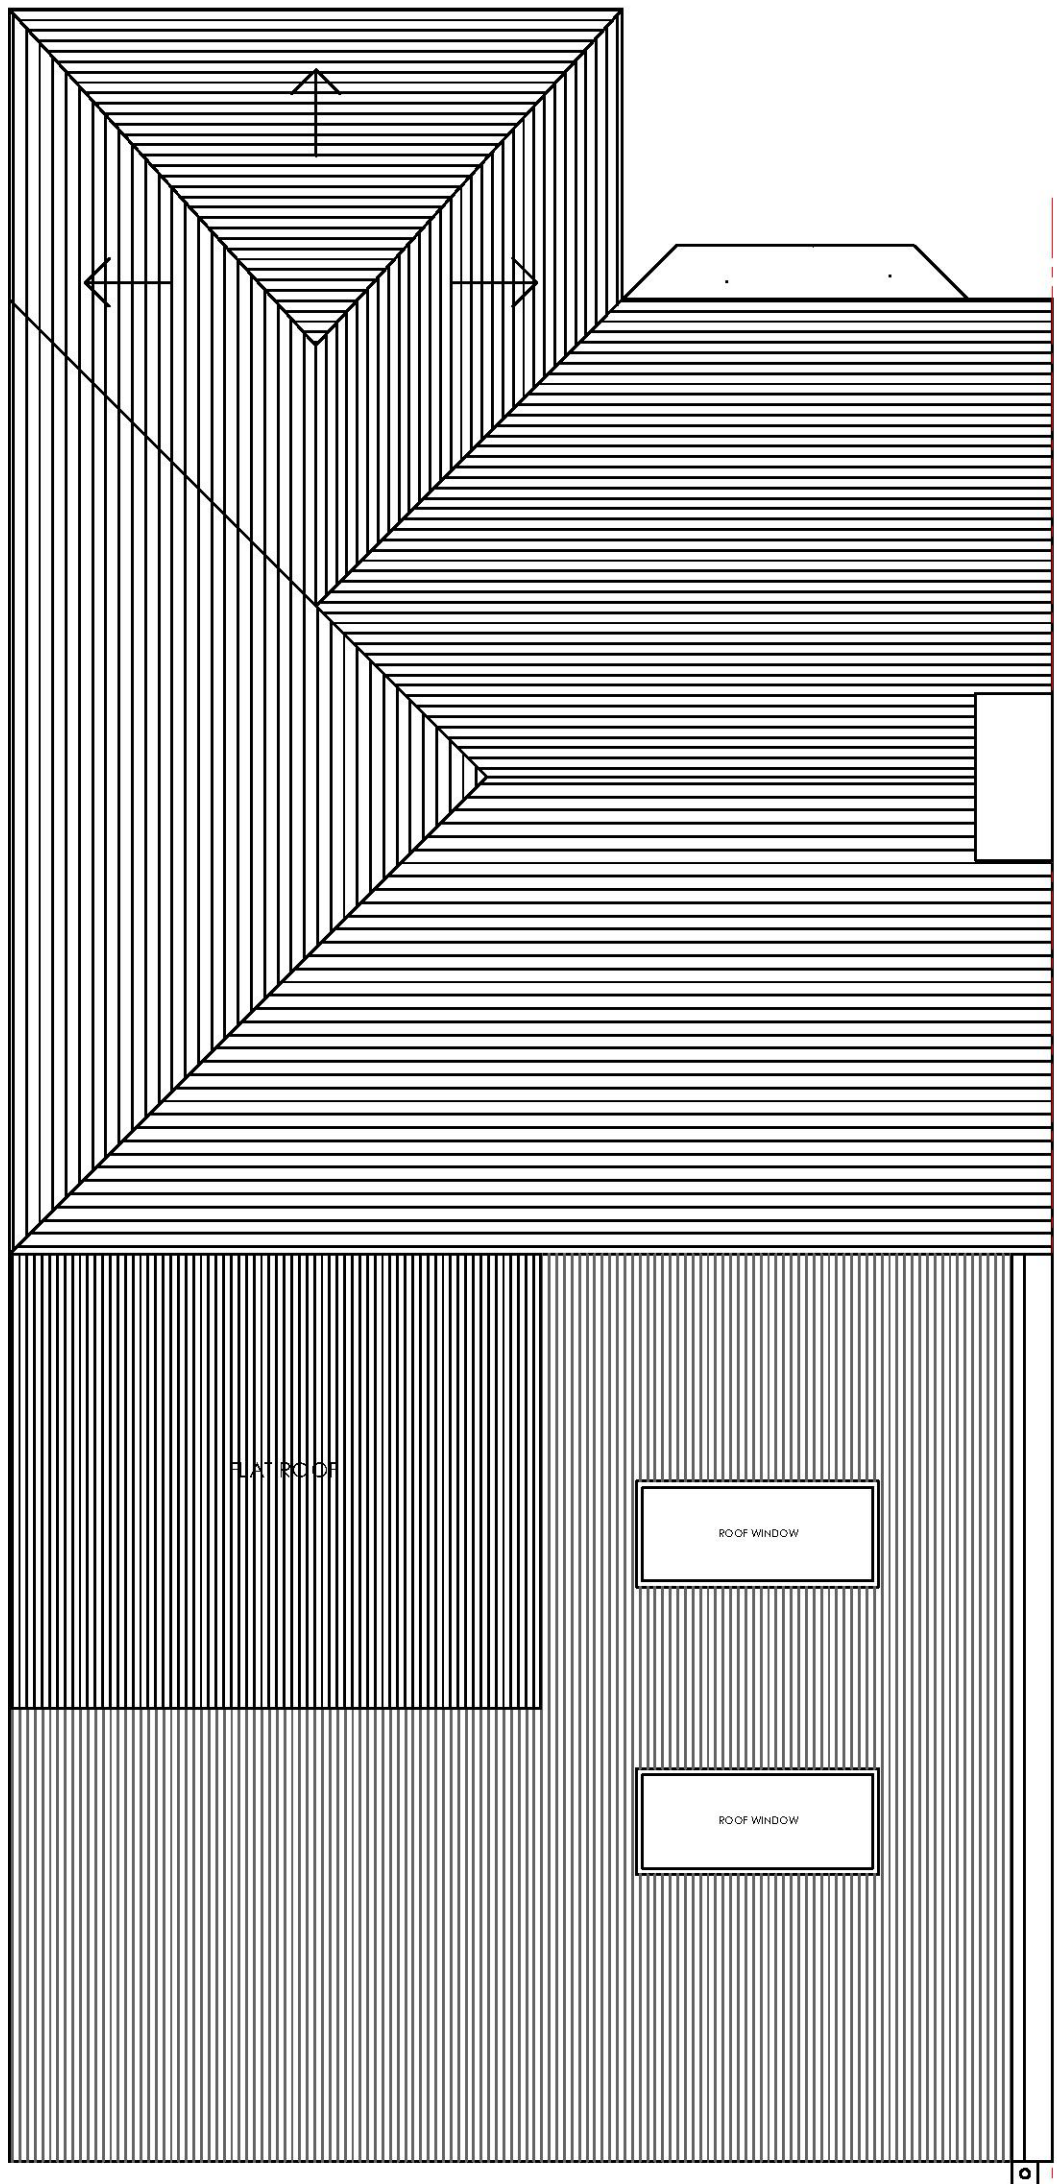

PROPOSED ROOF PLAN

FLOOR PLANS KEYS

- GROUND GAS METER BOX
- ELECTRIC METER BOX
- EXTRACTOR FAN - COOKER HOOD
- EXTRACTOR FAN - WALL/CEILING MOUNTED
30 LITRES/SEC IN KITCHEN AND UTILITY ROOM
15 LITRES/SEC IN BATHROOM
6 LITRES/SEC IN W/C
- SMOKE DETECTOR - MAINS OPERATED,
BATTERY BACK-UP
- HEAT DETECTOR - MAINS OPERATED,
BATTERY
- 30 MINUTES FIRE RESISTANT
- RAIN WATER PIPE
- SOIL WAST PIPE (s/wp - Vent pipe, SS
- Stub stack, AAV - Air admittance
valve)
- PROPOSED WALL / BRICK WORK
- PROPOSED WALL / BLOCK WORK
- PROPOSED ROOF
- DEMOLISHED
- INSULATION
- EXISTING WALL
- WATER POINT (POSITION/HEIGHT TBC)
- GAS OUTLET FOR STOVE (POSITION/HEIGHT TBC)
- DOUBLE SWITCHED WALL SOCKET
- TRIPLE SWITCHED FLOOR SOCKET
- LIGHT POINT DOWNLIGHTER/PENDANT HOLDER
(POSITION TBC ON SITE)


NOTES:

SHORPLANS architects


Figured dimensions only are to be used. All dimensions to be checked on site. Differences between drawings and between drawings and specification or bills of quantities to be reported to SHORPLANS architects.

The copyright of the drawing and designs remains SHORPLANS architects.

All copies are only for information about the application, they may not be used for any other purpose without the express written permission of SHORPLANS architects.

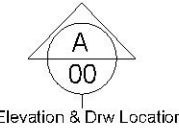


Elevation & Draw Location

 


Section & Draw Location

DRAWING NO	DATE	DRAWING	PROJECT
80-003	27.09.21	PROPOSED PLANS	80 EYHURST AVENUE
DRAWN	SCALE		
LD	1:50 @ A1		

 



EXISTING FRONT ELEVATION

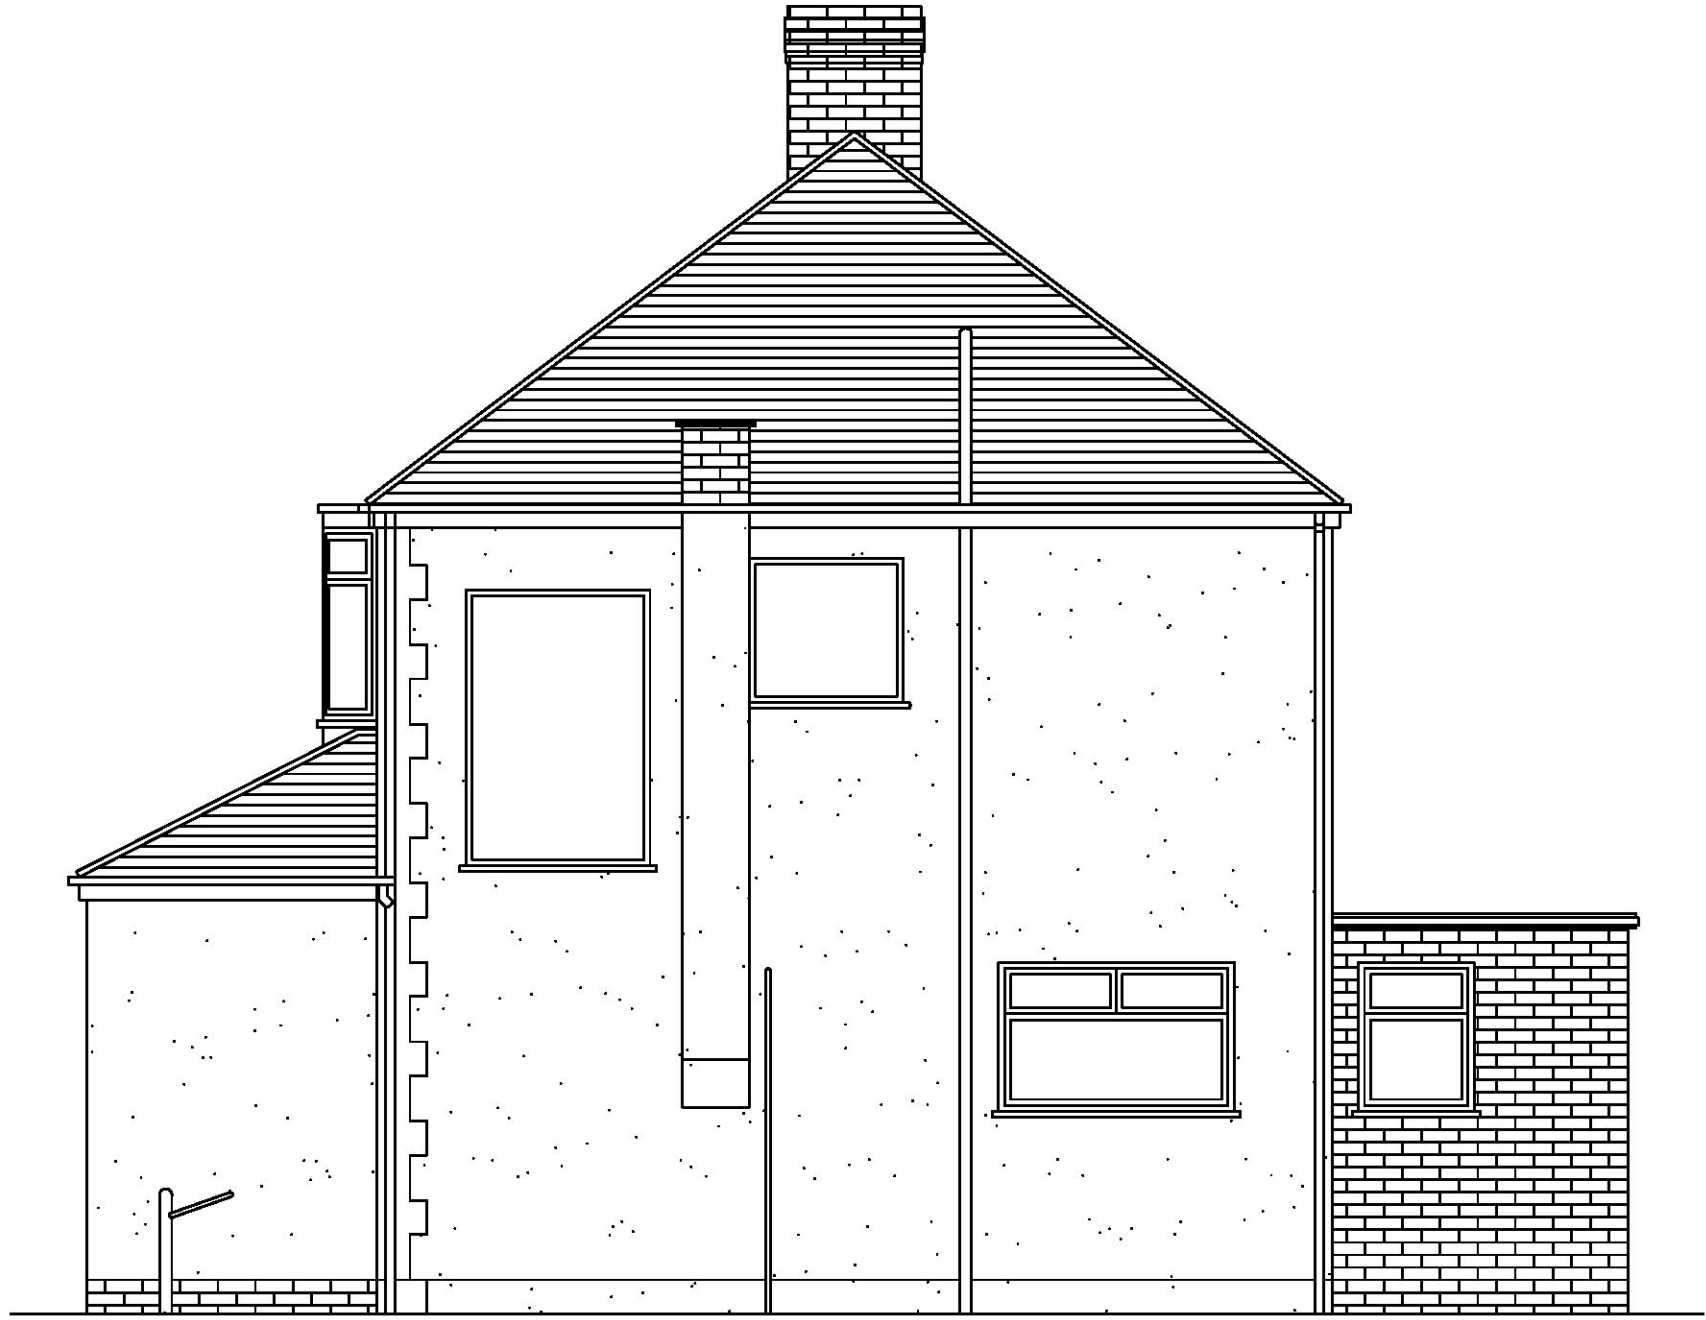

EXISTING RIGHT SIDE ELEVATION



 
EXISTING REAR ELEVATION



EXISTING LEFT SIDE ELEVATION

FLOOR PLANS KEYS

- GROUND GAS METER BOX
- ELECTRIC METER BOX
- EXTRACTOR FAN - COOKER HOOD
- EXTRACTOR FAN - WALL/CEILING MOUNTED
30 LITRES/SEC IN KITCHEN AND UTILITY ROOM
15 LITRES/SEC IN BATHROOM
6 LITRES/SEC IN WC
- SMOKE DETECTOR - MAINS OPERATED,
BATTERY BACK-UP
- HEAT DETECTOR - MAINS OPERATED,
BATTERY
- 30 MINUTES FIRE RESISTANT
- RAIN WATER PIPE
- SOIL WAST PIPE (snp - Vent pipe, SS
- Sub stack, AAV - Air admittance
valve)
- PROPOSED WALL / BRICK WORK
- PROPOSED WALL / BLOCK WORK
- PROPOSED ROOF
- DEMOLISHED
- INSULATION
- EXISTING WALL




02 EXISTING ELEVATIONS
SCALE 1:50 @ A1

SHORPLANS
ARCHITECTURAL SERVICES
17-21 GEORGE STREET
CROYDON, SURREY
CR0 1LA
WWW.SHORPLANS.COM
ADMIN@SHORPLANS.COM
020 38806164

RIBA
Chartered Practice

NOTES:
SHORPLANS architects
Figured dimensions only are to be used. All dimensions to be checked on site. Differences between drawings and between drawings and specification or bills of quantities to be reported to SHORPLANS architects.
The copyright of the drawing and designs remains SHORPLANS architects.
All copies are only for information about the application, they may not be used for any other purpose without the express written permission of SHORPLANS architects.

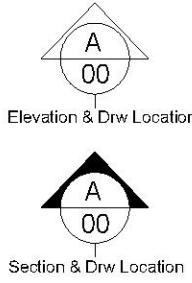

DRAWING NO	DATE	DRAWING	PROJECT
80-002	27.09.21	EXISTING ELEVATIONS	80 EYHURST AVENUE
DRAWN	SCALE		
LD	1:50 @ A1		