

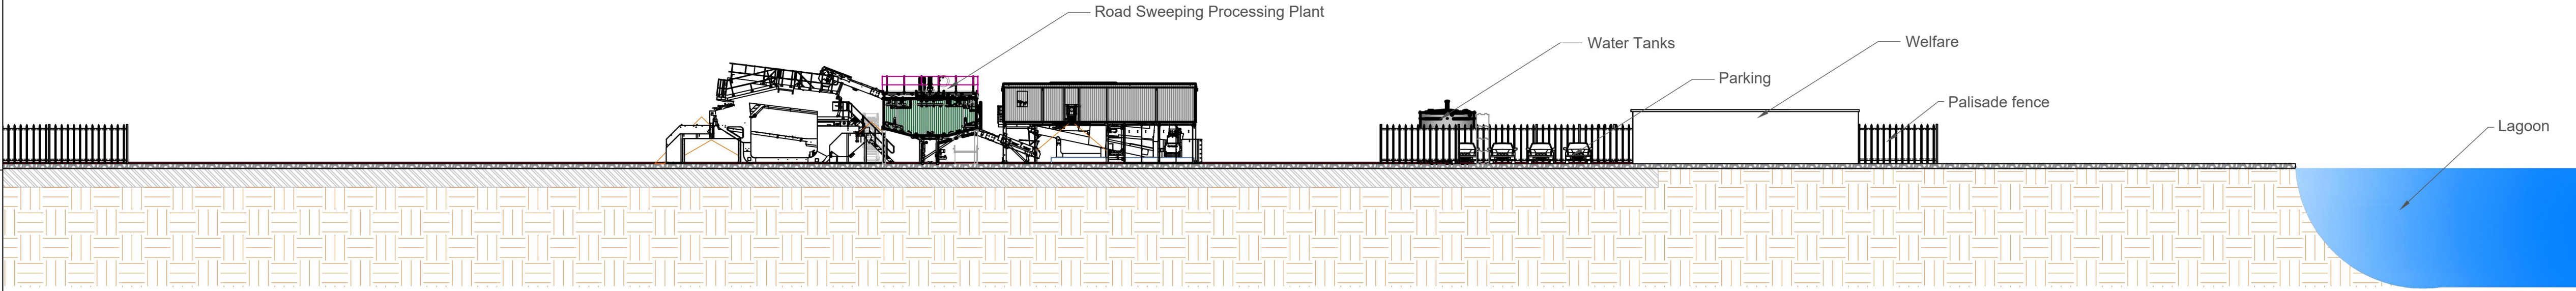


Drawing No.
VES TD SOILREP 300 011

NORTH-EAST ELEVATION

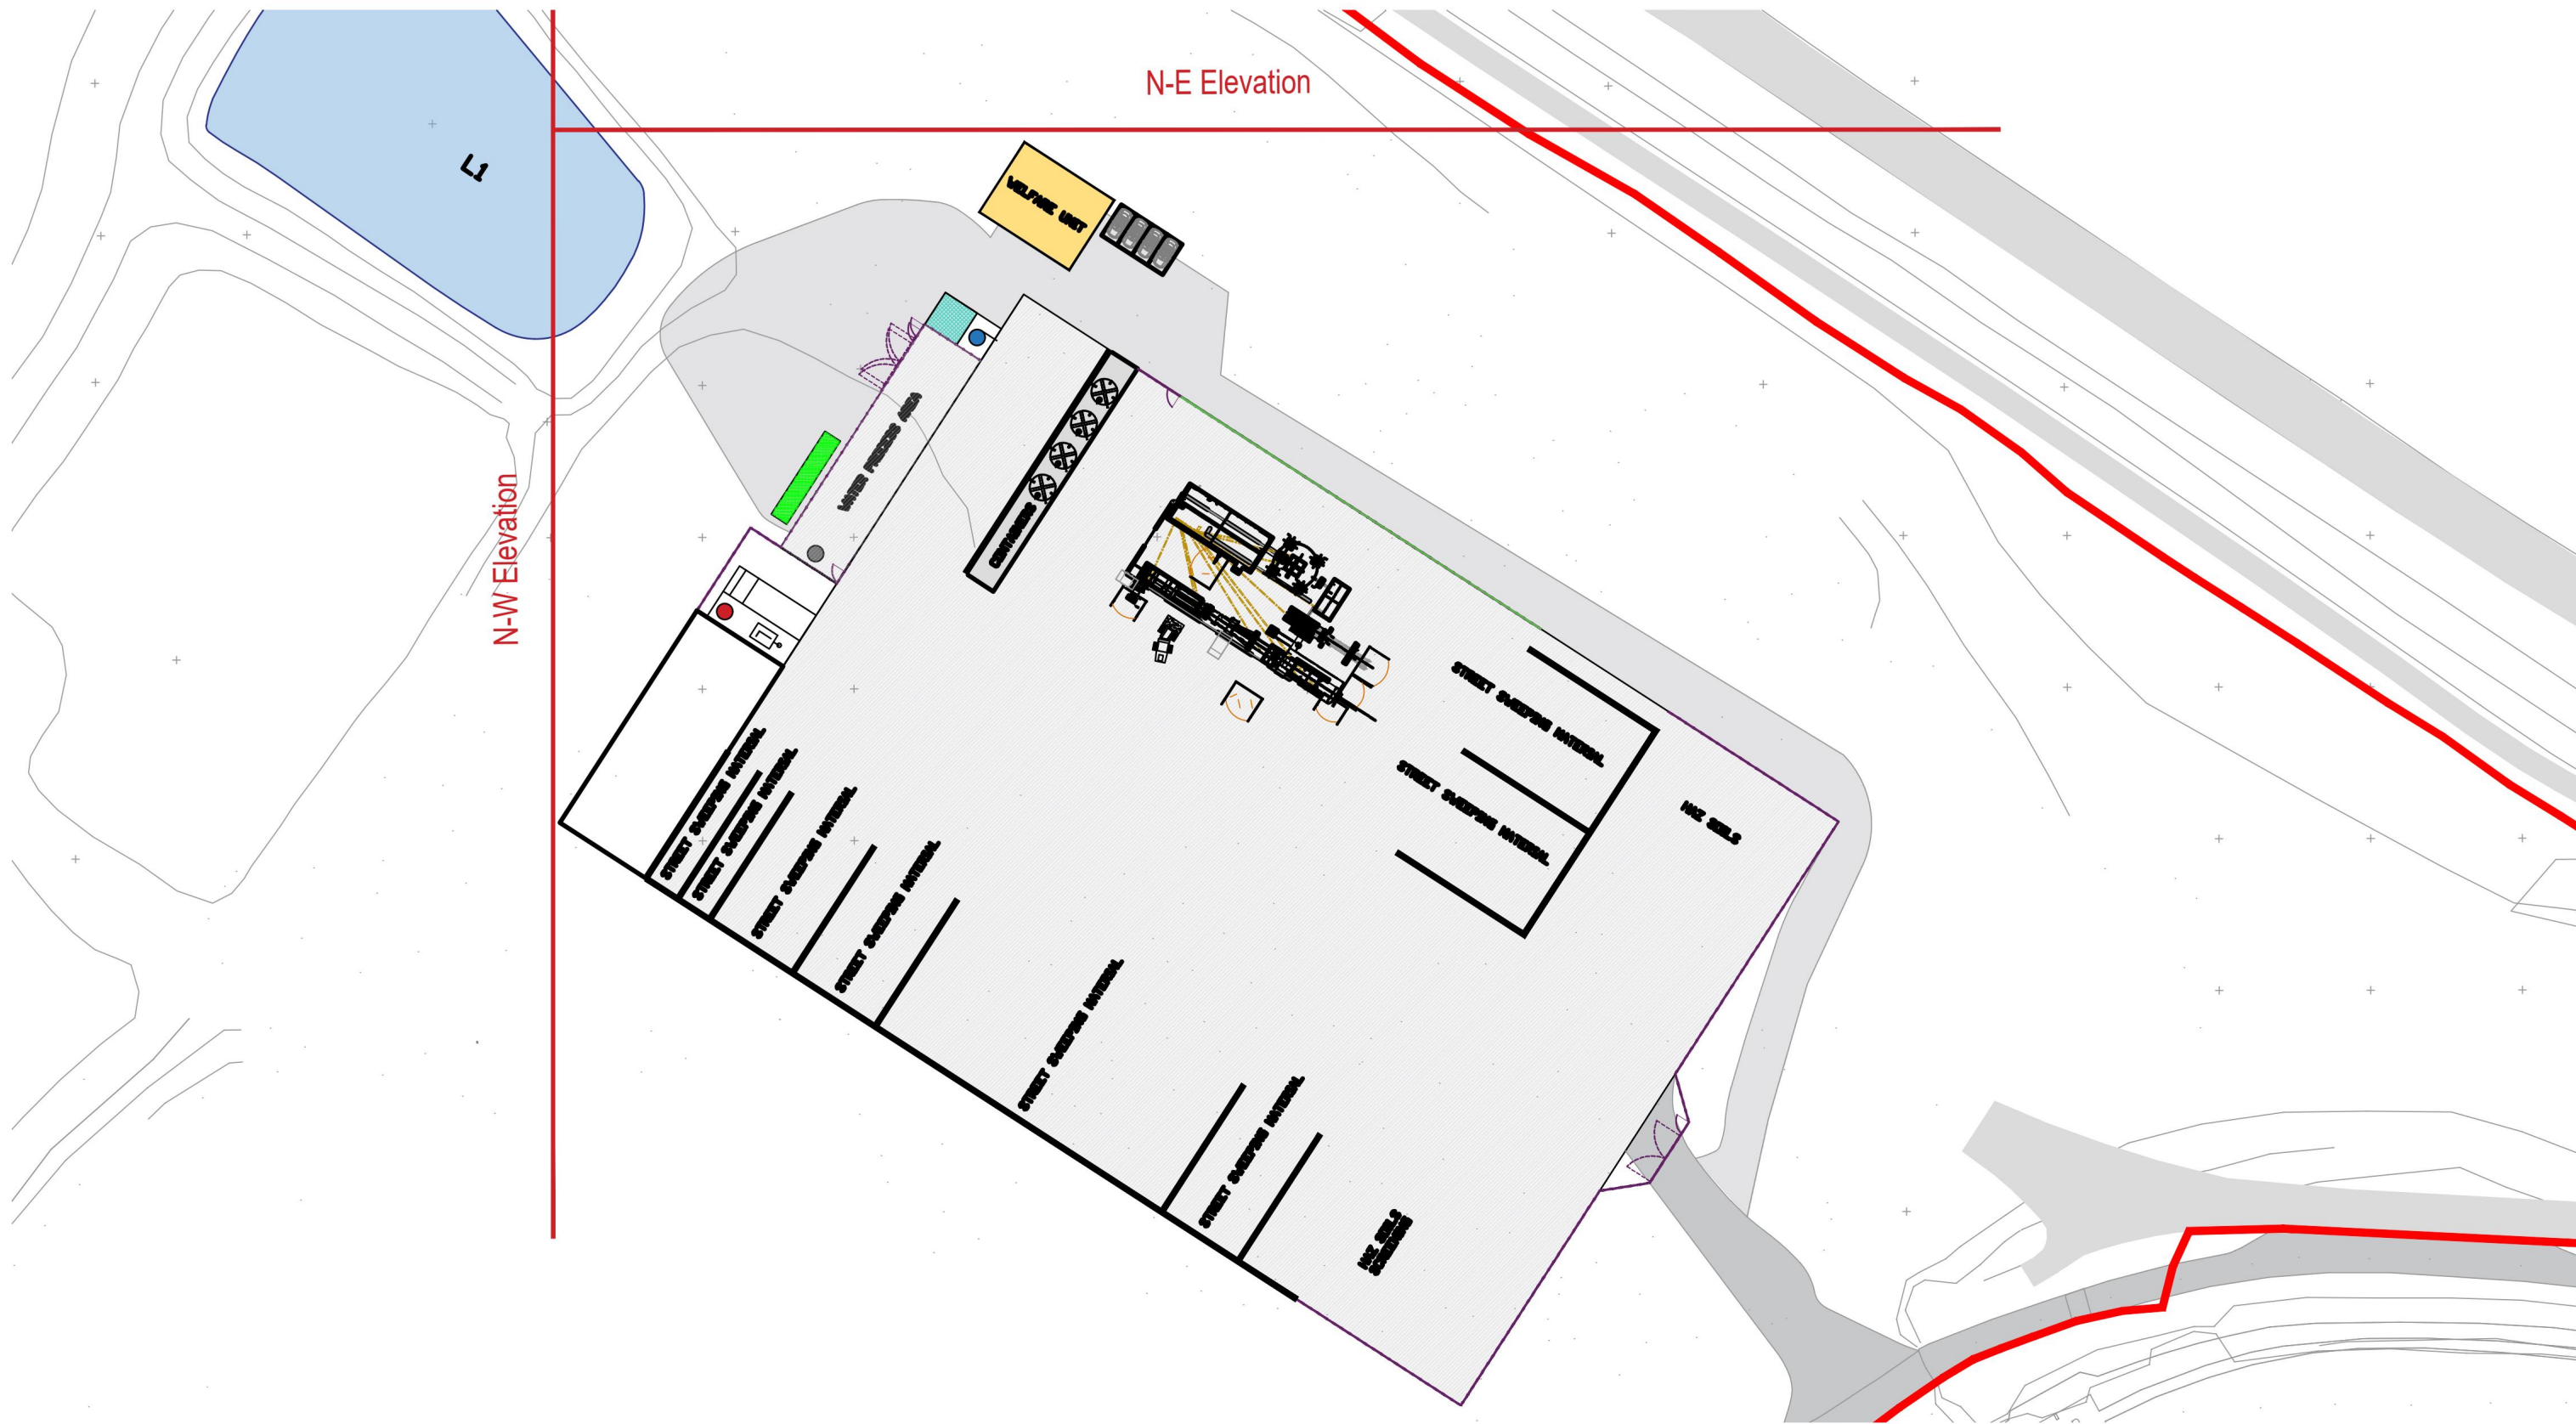

NORTH-EAST ELEVATION

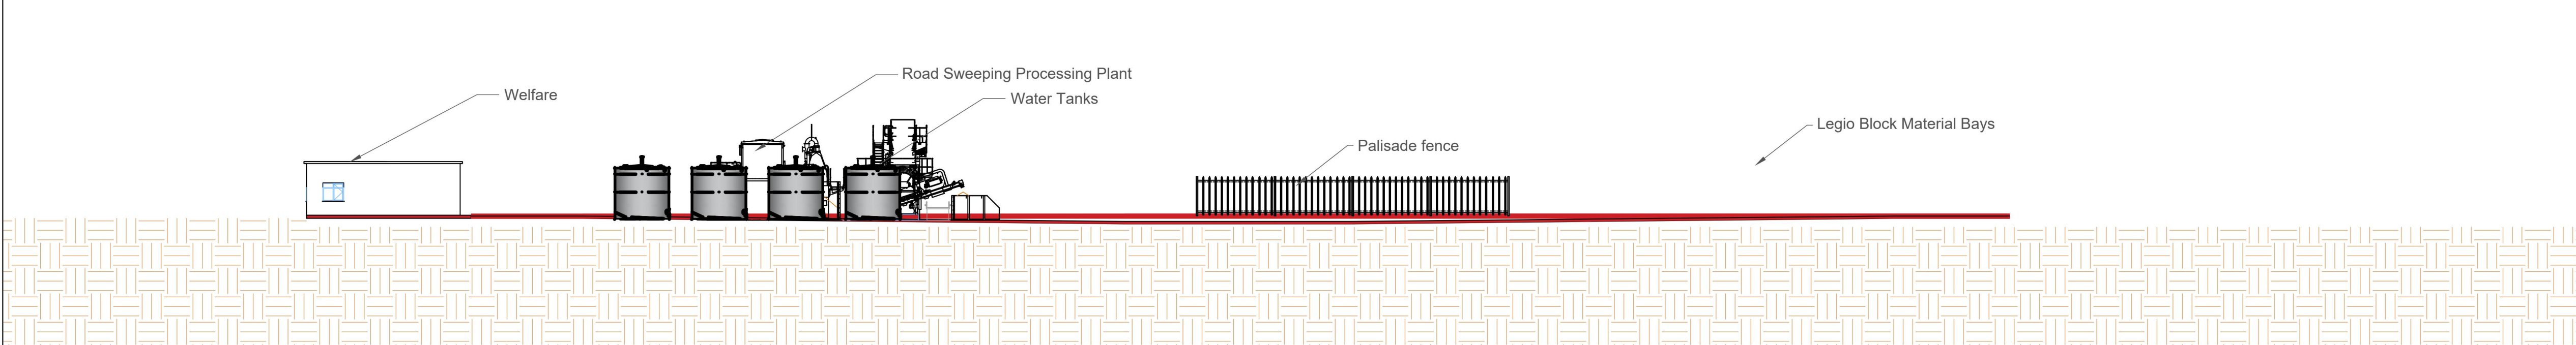

- GENERAL NOTES:
1. THIS DRAWING IS COPYRIGHT AND THE PROPERTY OF VEOLIA AND IS NOT TO BE COPIED IN WHOLE OR IN PART EXCEPT UNDER A WRITTEN AGREEMENT.
 2. DETAILS SHOWN ON DRAWINGS ARE FOR REFERENCE PURPOSES ONLY.
 3. THIS IS A CONCEPTUAL DRAWING SUBJECT TO DETAILED DESIGN BY A DESIGN & BUILD CONTRACTOR.
 4. IN CASE OF ANY DISCREPANCY BETWEEN THE DRAWING AND THE WORKS INFORMATION, THE WORKS INFORMATION WILL TAKE PRECEDENCE AND THE CONTRACTOR WILL BE DEEMED TO HAVE INTENDED TO COMPLY WITH THE WORKS INFORMATION AND SHALL DO SO.
 5. ALL DIMENSIONS AND LEVELS ARE TO BE CHECKED ON SITE BY THE CONTRACTOR PRIOR TO PREPARING ANY WORKING DRAWINGS OR COMMENCING ON SITE.
 - 6.PLEASE ENSURE DRAWING LICENCE DATE IS STILL VALID. ALL LICENCES ARE 12 MONTH UNLESS OTHERWISE STATED.

Rev	Description of revision	Drawn	Chkd	App	Date



Technical Direction,
8th Floor, 210 Pentonville Road, London. N1 9JY
Tel: 0207 812 5185


Project
**SOIL REPAIR CENTRE
RAINHAM**

Title
ELEVATIONS

	Initials	Date	Scale	Sheet size
Drawn	RB	08.04.24	1:250@A1;1:500@A3	A1
Checked				
Approved			© Copyright Reserved	

Job No.	SOILREP
Drawing No.	VES_TD_SOILREP_300_012
Revision	-

PLANNING

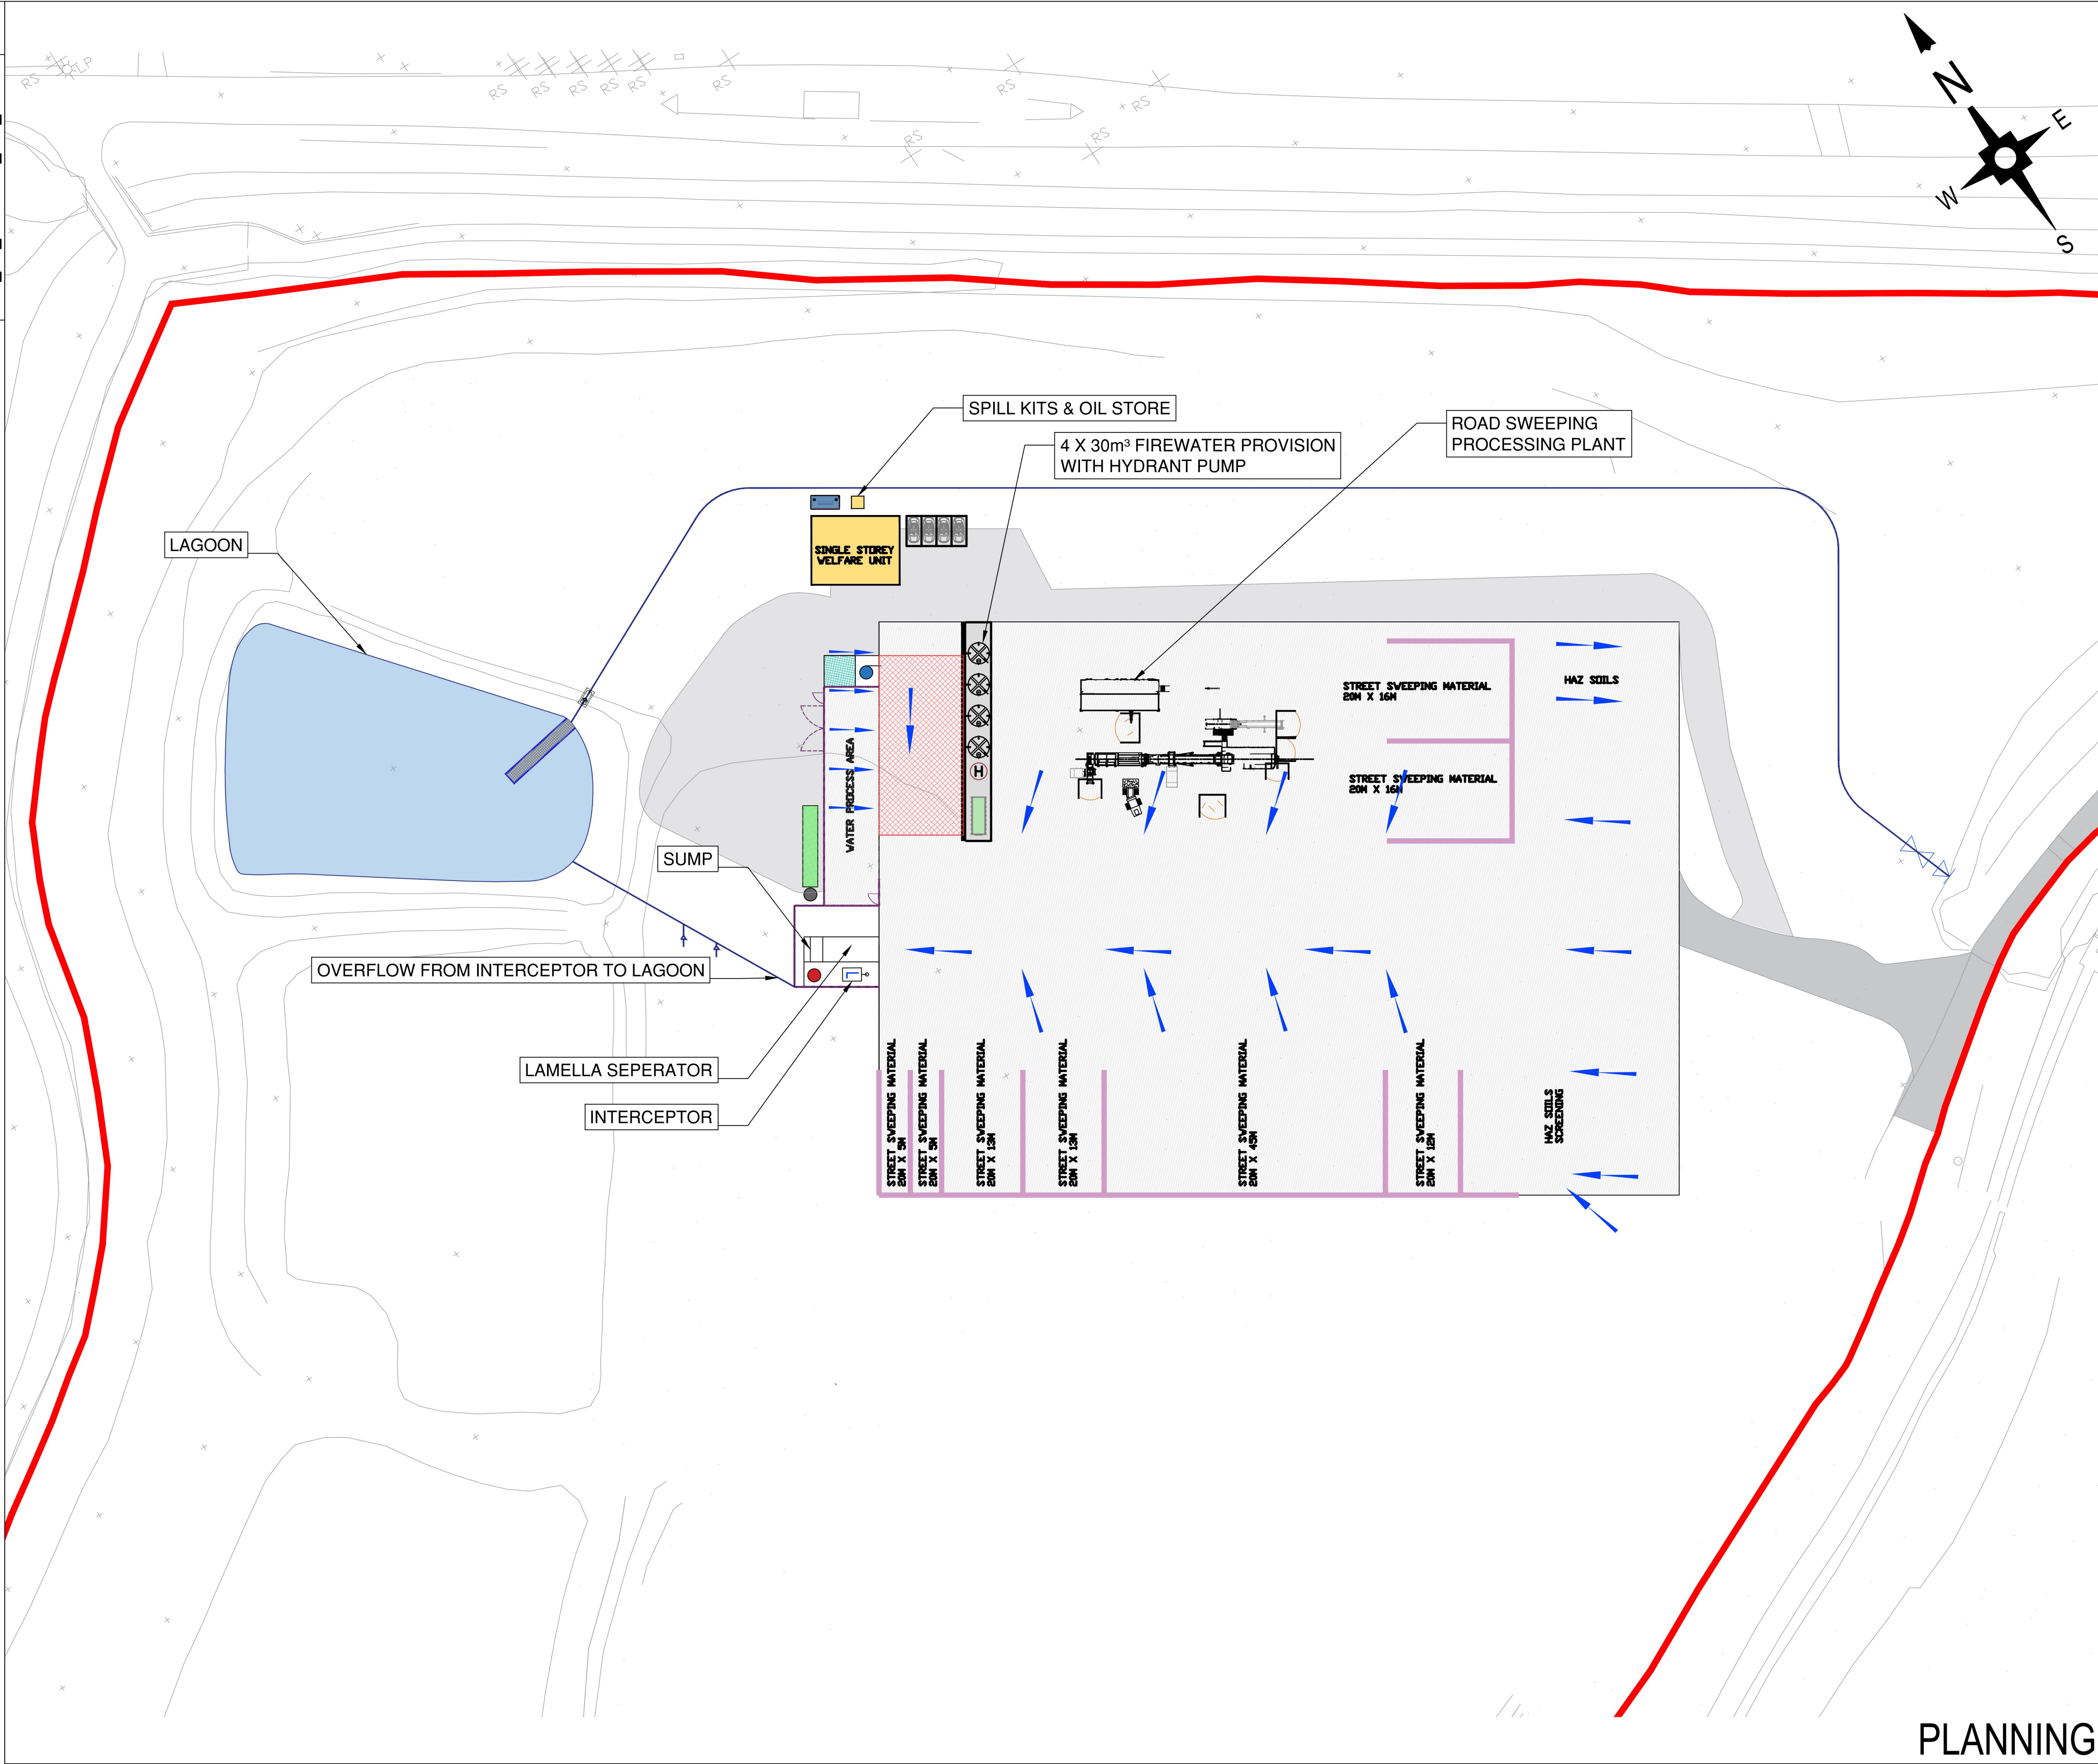

PLANNING

GENERAL NOTES:

- THIS DRAWING IS COPYRIGHT AND THE PROPERTY OF VEOLIA AND IS NOT TO BE COPIED IN WHOLE OR IN PART EXCEPT UNDER A WRITTEN AGREEMENT.
- DETAILS SHOWN ON DRAWINGS ARE FOR REFERENCE PURPOSES ONLY.
- THIS IS A CONCEPTUAL DRAWING SUBJECT TO DETAILED DESIGN BY A DESIGN & BUILD CONTRACTOR.
- IN CASE OF ANY DISCREPANCY BETWEEN THE DRAWING AND THE WORKS INFORMATION, THE WORKS INFORMATION WILL TAKE PRECEDENCE AND THE CONTRACTOR WILL BE DEEMED TO HAVE INTENDED TO COMPLY WITH THE WORKS INFORMATION AND SHALL DO SO.
- ALL DIMENSIONS AND LEVELS ARE TO BE CHECKED ON SITE BY THE CONTRACTOR PRIOR TO PREPARING ANY WORKING DRAWINGS OR COMMENCING ON SITE.
- PLEASE ENSURE DRAWING LICENCE DATE IS STILL VALID. ALL LICENCES ARE 12 MONTH UNLESS OTHERWISE STATED.

SITE LOCATION PLAN

SITE BOUNDARY

SURFACED AREAS

DRAINAGE KEY

- PROPOSED TREATED WATER DRAINAGE
- FALLS

A	WATER TREATMENT MOVED	RB			14.05.24
Rev	Description of revision	Drawn	Chkd	App	Date

VEOLIA

Technical Direction,
8th Floor, 210 Pentonville Road, London. N1 9JY
Tel: 0207 812 5185

Project

SOIL REPAIR CENTRE
EXPANSION PROJECT - RAINHAM

Title


SOIL REPAIR CENTRE
PROPOSED DRAINAGE LAYOUT

	Initials	Date	Scale	Sheet size
Drawn	RB	12.06.24	1:500@A1	A1
Checked				
Approved			© Copyright Reserved	

Job No. SOILREP

Drawing No. VES_TD_SOILREP_300_016

Revision -

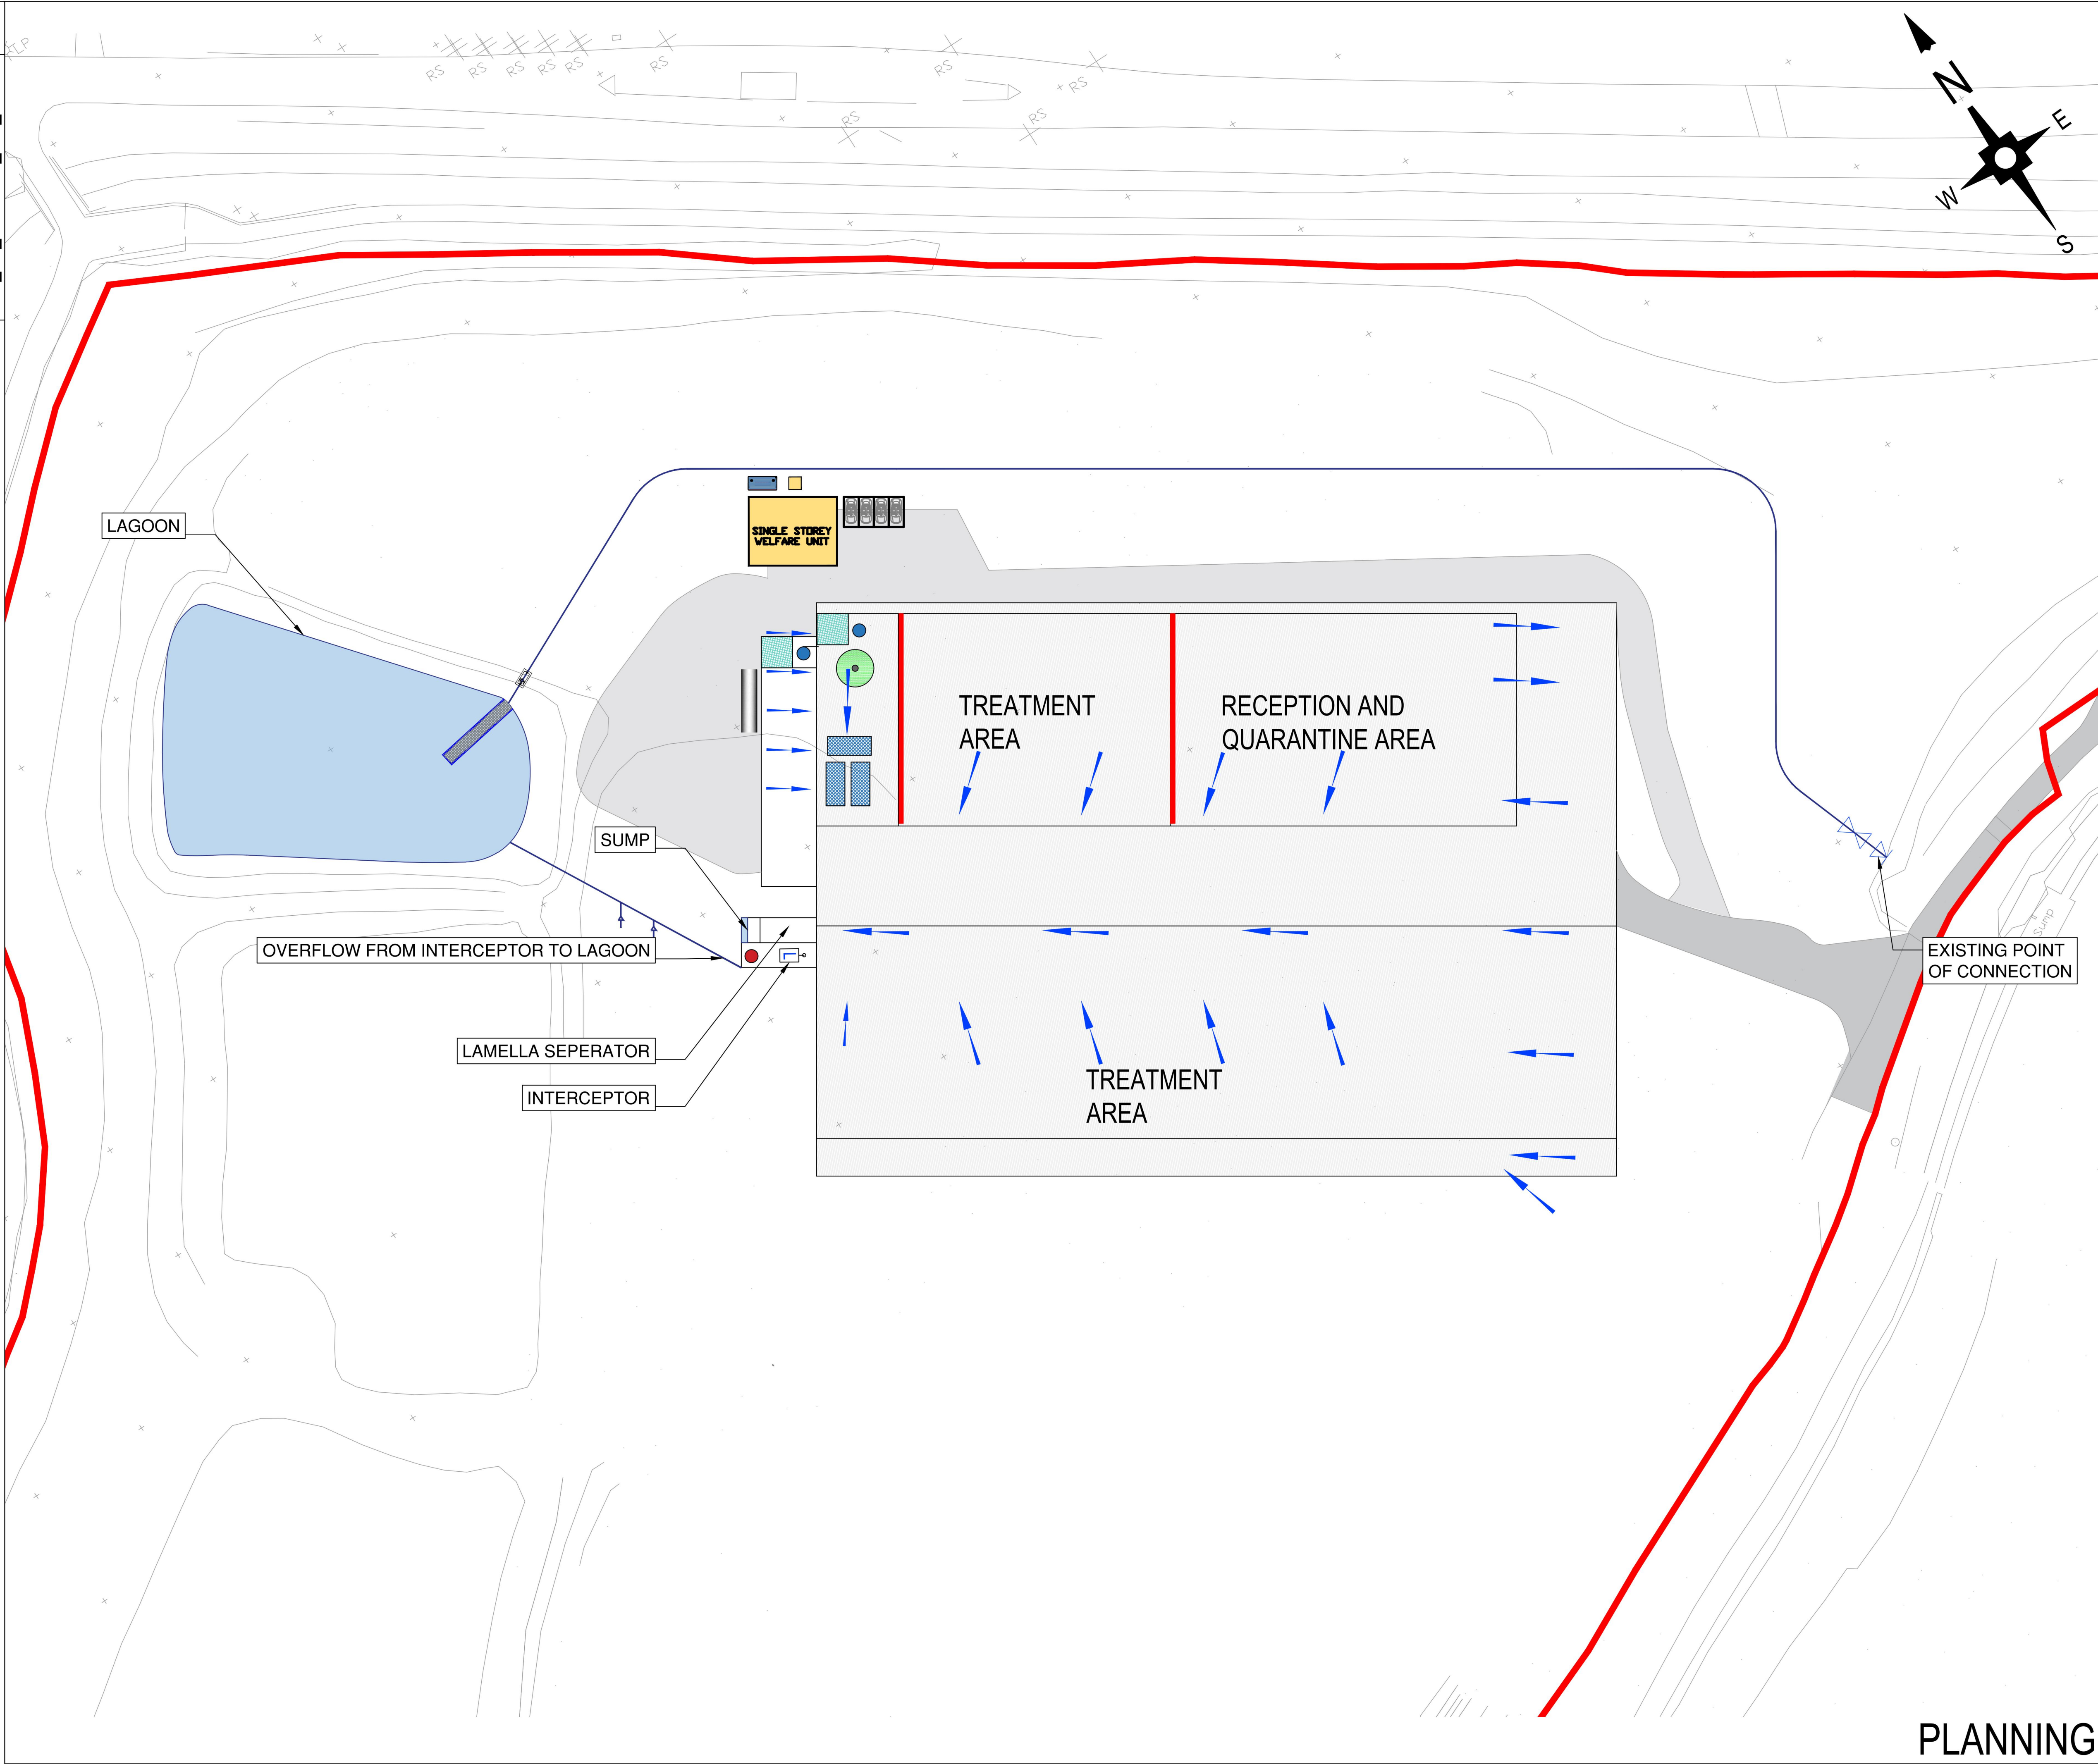

GENERAL NOTES:

1. THIS DRAWING IS COPYRIGHT AND THE PROPERTY OF VEOLIA AND IS NOT TO BE COPIED IN WHOLE OR IN PART EXCEPT UNDER A WRITTEN AGREEMENT.

2. DETAILS SHOWN ON DRAWINGS ARE FOR REFERENCE PURPOSES ONLY.

3. THIS IS A CONCEPTUAL DRAWING SUBJECT TO DETAILED DESIGN BY A DESIGN & BUILD CONTRACTOR.

4. IN CASE OF ANY DISCREPANCY BETWEEN THE DRAWING AND THE WORKS INFORMATION, THE WORKS INFORMATION WILL TAKE PRECEDENCE AND THE CONTRACTOR WILL BE DEEMED TO HAVE INTENDED TO COMPLY WITH THE WORKS INFORMATION AND SHALL DO SO.

5. ALL DIMENSIONS AND LEVELS ARE TO BE CHECKED ON SITE BY THE CONTRACTOR PRIOR TO PREPARING ANY WORKING DRAWINGS OR COMMENCING ON SITE.

6. PLEASE ENSURE DRAWING LICENCE DATE IS STILL VALID. ALL LICENCES ARE 12 MONTH UNLESS OTHERWISE STATED.

SITE LOCATION PLAN

SITE BOUNDARY

SURFACED AREAS

DRAINAGE KEY

PROPOSED SURFACE WATER DRAINAGE

FALLS

A	WATER TREATMENT MOVED	RB			14.05.24
Rev	Description of revision	Drawn	Chkd	App	Date

VEOLIA

Technical Direction,
8th Floor, 210 Pentonville Road, London. N1 9JY
Tel: 0207 812 5185

Project

SOIL REPAIR CENTRE
EXPANSION PROJECT - RAINHAM

Title

SOIL REPAIR CENTRE
EXISTING DRAINAGE LAYOUT

	Initials	Date	Scale	Sheet size
Drawn	RB	12.06.24	1:500@A1	A1
Checked				
Approved			© Copyright Reserved	

Job No. SOILREP

PLANNING

Drawing No. VES_TD_SOILREP_300_017

Revision -